



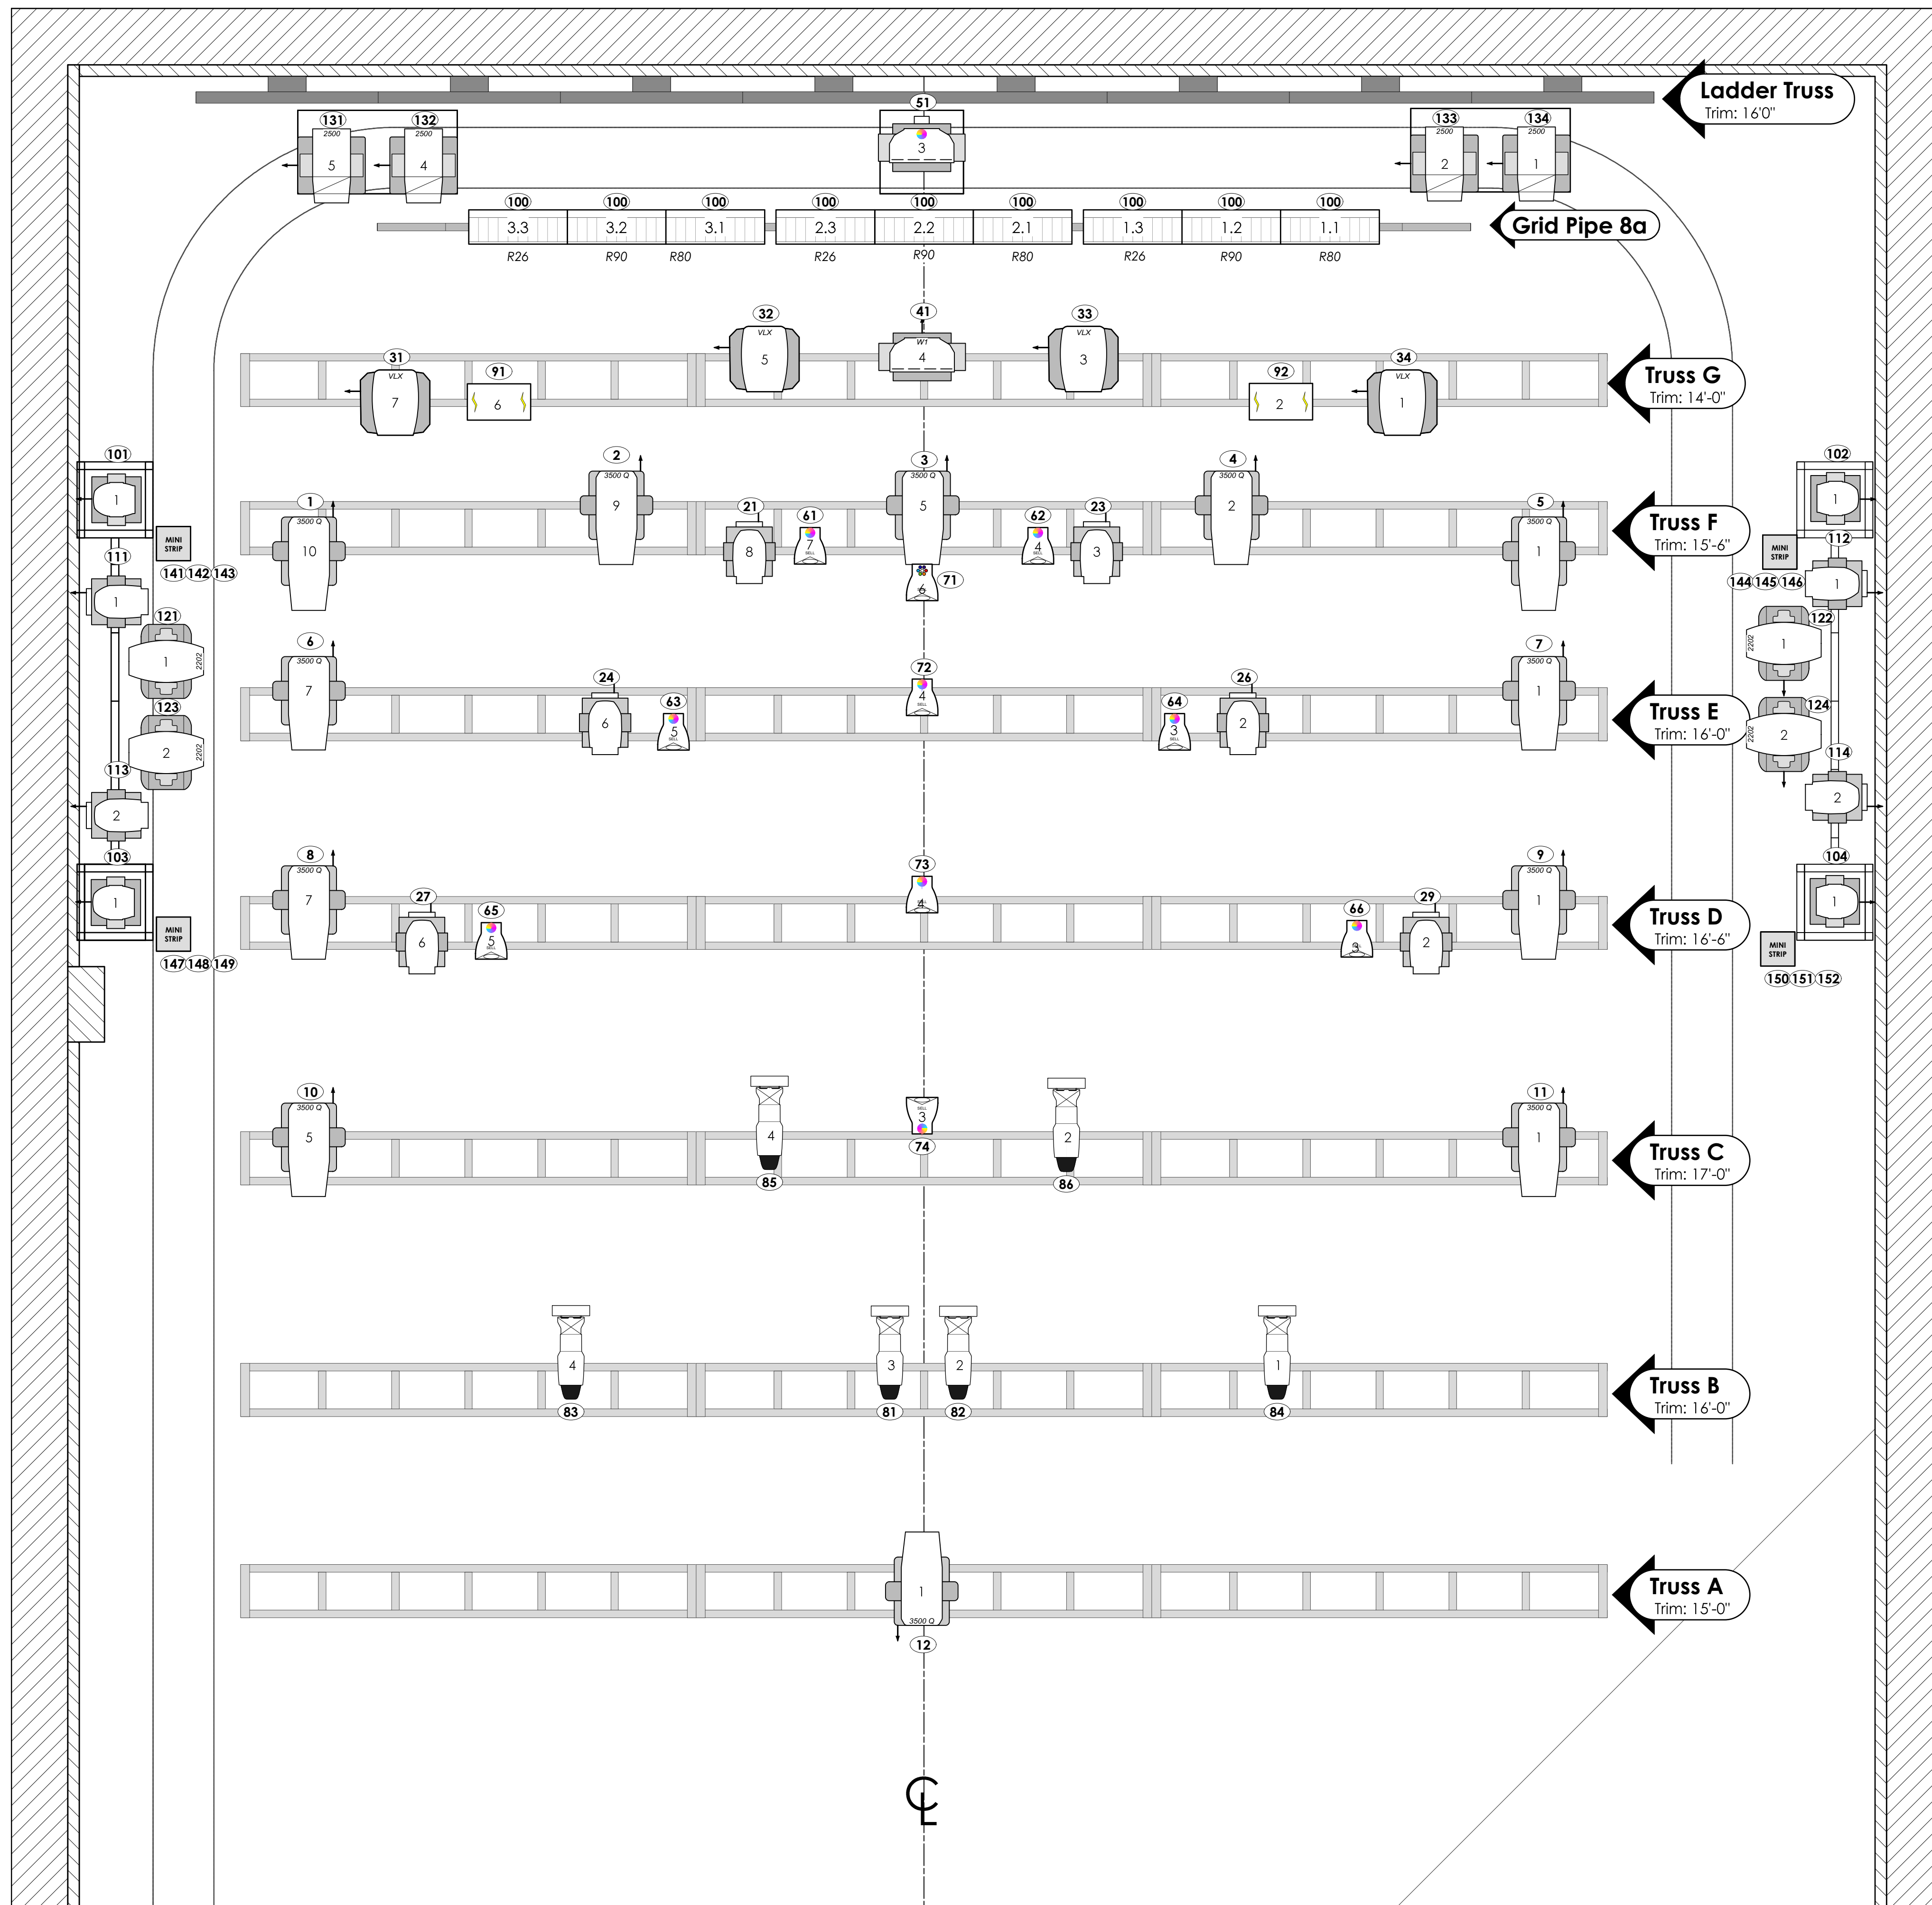


Symbol Key


Moving Light

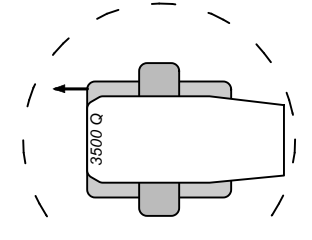


Varilite VL 3500 Q Spot

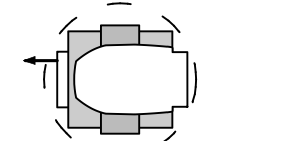


Clay Paky Sharpy Wash 330

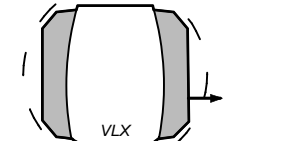


Varilite VLX Wash

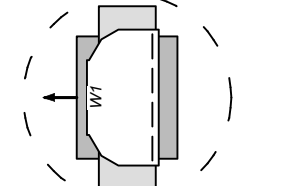


High End ShapeShifter White

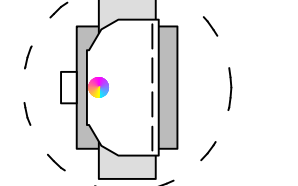


High End ShapeShifter Color

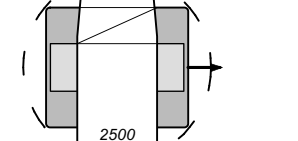

Varilite VL 2500 Spot

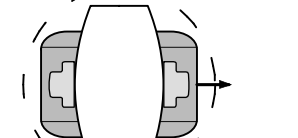


Varilite VL 2202

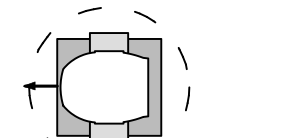


Clay Paky Sharpy


Conventional

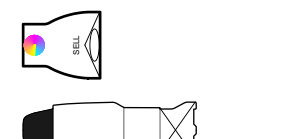


ETC D40 Lustr SELL40

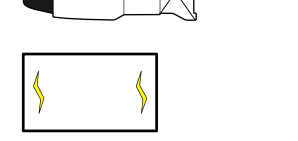


ETC Source4 19deg 750W

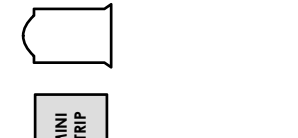

Martin Atomic 3000 DMX

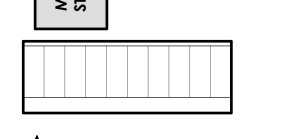

Selecon Acclaim Fresnel

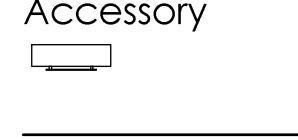

Altman Zip Strip



Altman Zip Strip



Wybron Forerunner 4"

Accessory



Typical



Typical



Typical



Typical




Typical



Typical



Typical

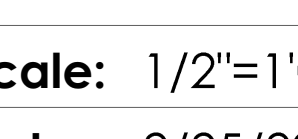


Typical



Typical



 Typical



Typical

2	Class Submission	10/14/2019
1	Prelim	10/8/2019

WELLS CONCERT RIG
FALL 2020

Filename:
Wells F20 Rig Feb20 Update.vwx

Drawn By:
A. TALBOT

Scale: 1/2"=1'0"


Date: 2/25/20

Page #

1


Of: 6

Combined Light Plot

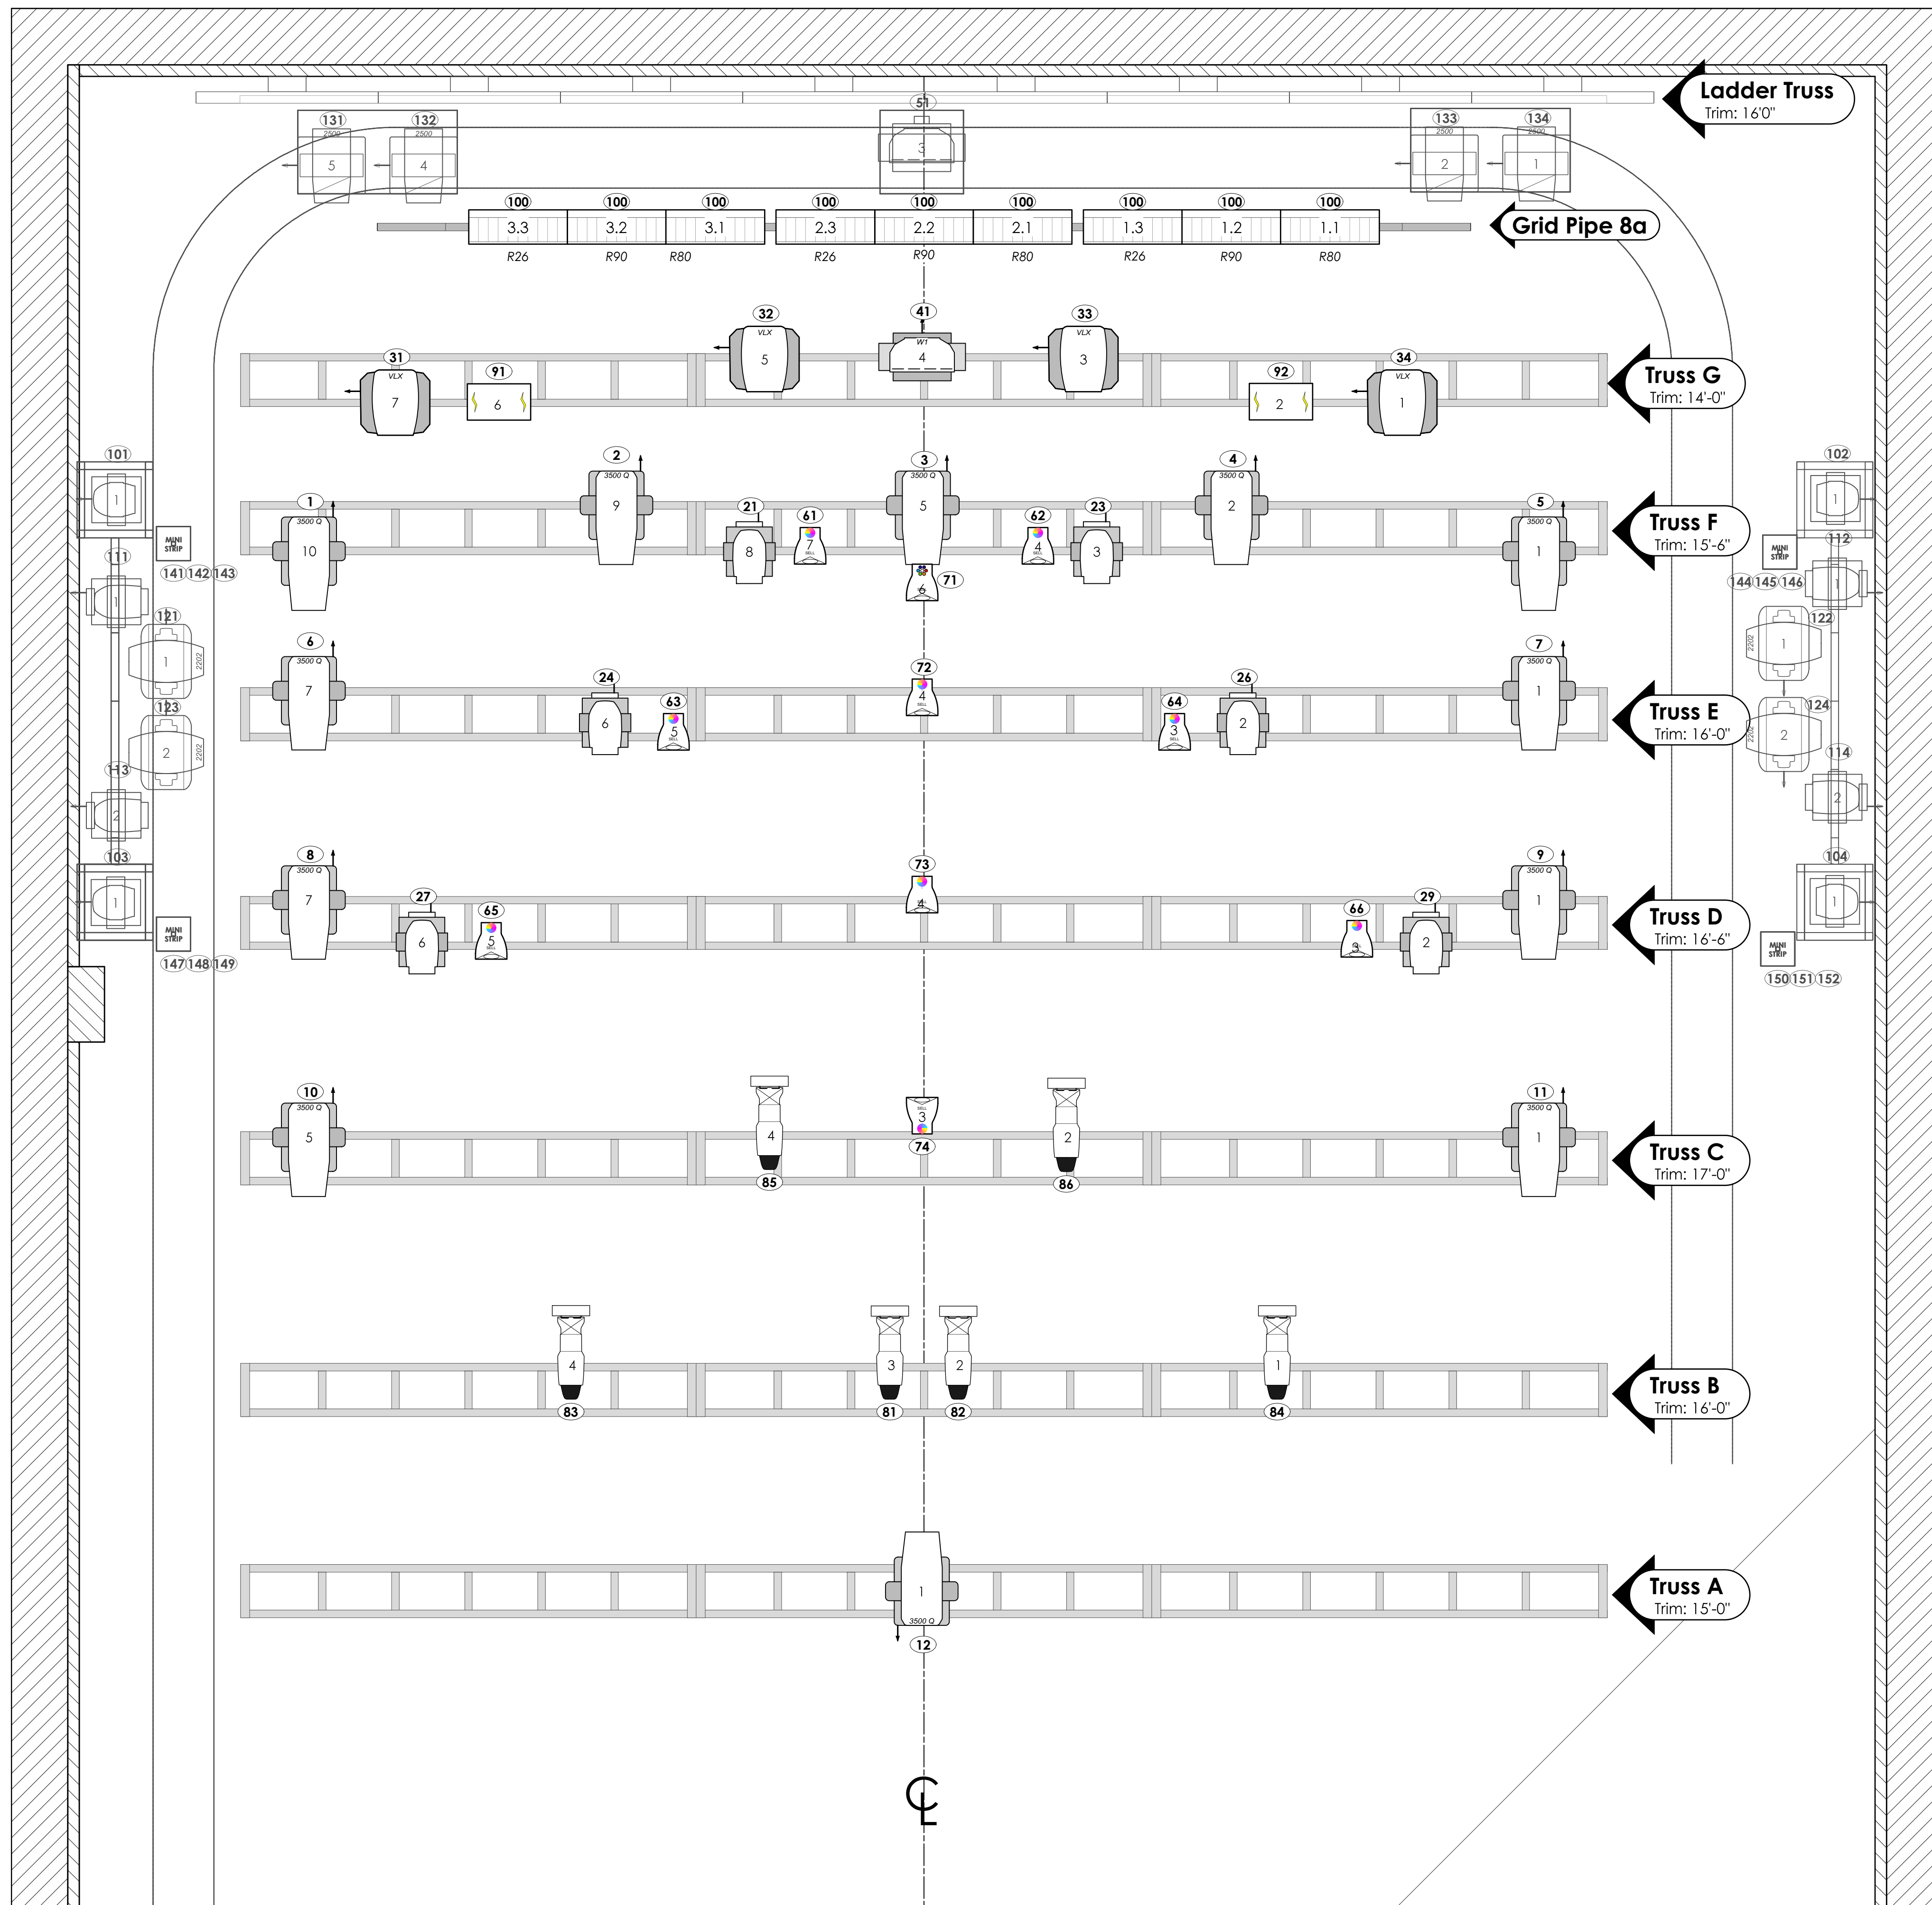

Symbol Key

Moving Light

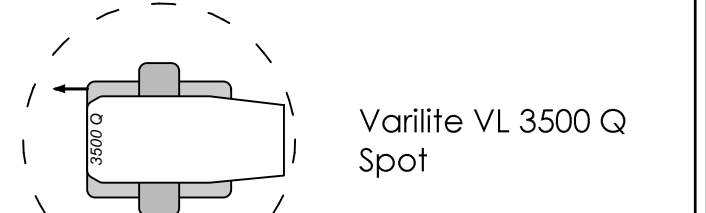

Varilite VL 3500 Q Spot



 
Clay Paky Sharpy Wash 330



Varilite VLX Wash



High End ShapeShifter White




High End ShapeShifter Color



Varilite VL 2500 Spot



 Varilite VL 2202



Clay Paky Sharpy



 
Conventional




ETC D40 Lustr SELL40



ETC Source4 19deg 750W



Martin Atomic 3000 DMX

 


Selecon Acclaim Fresnel




Altman Zip Strip



 Altman Zip Strip



Wybron Forerunner 4"

 

Typical



Typical



Typical



Typical



Typical



 
Typical



Typical



2 Class Submission 10/14/2019
1 Prelim 10/8/2019

WELLS CONCERT RIG
FALL 2020

Filename:
Wells F20 Rig Feb20 Update.vwx

Drawn By:
A. TALBOT

Scale: 1/2"=1'0"

Date: 2/25/20

Page #


2

Of: 6

Overhead Light Plot


UPSTAGE DECK ELEVATION

SCALE: 1/2" = 1'0"

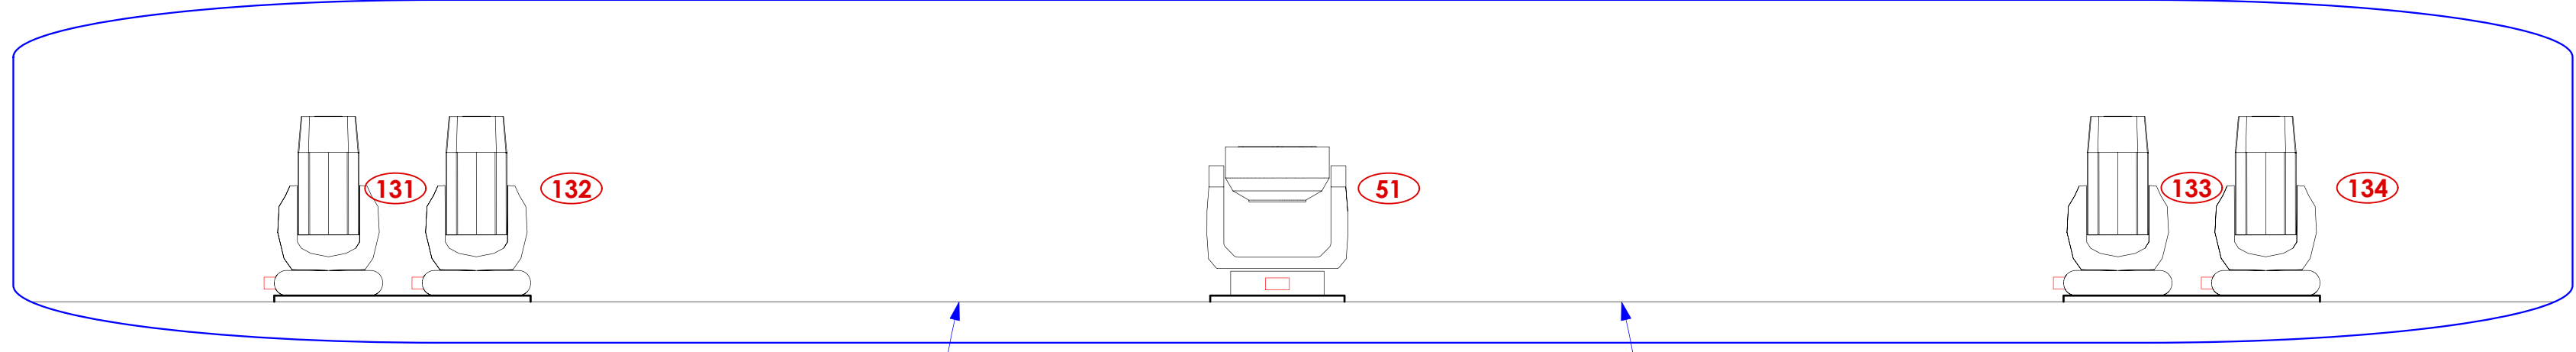


SR DECK ELEVATION

SCALE: 1/2" = 1'0"

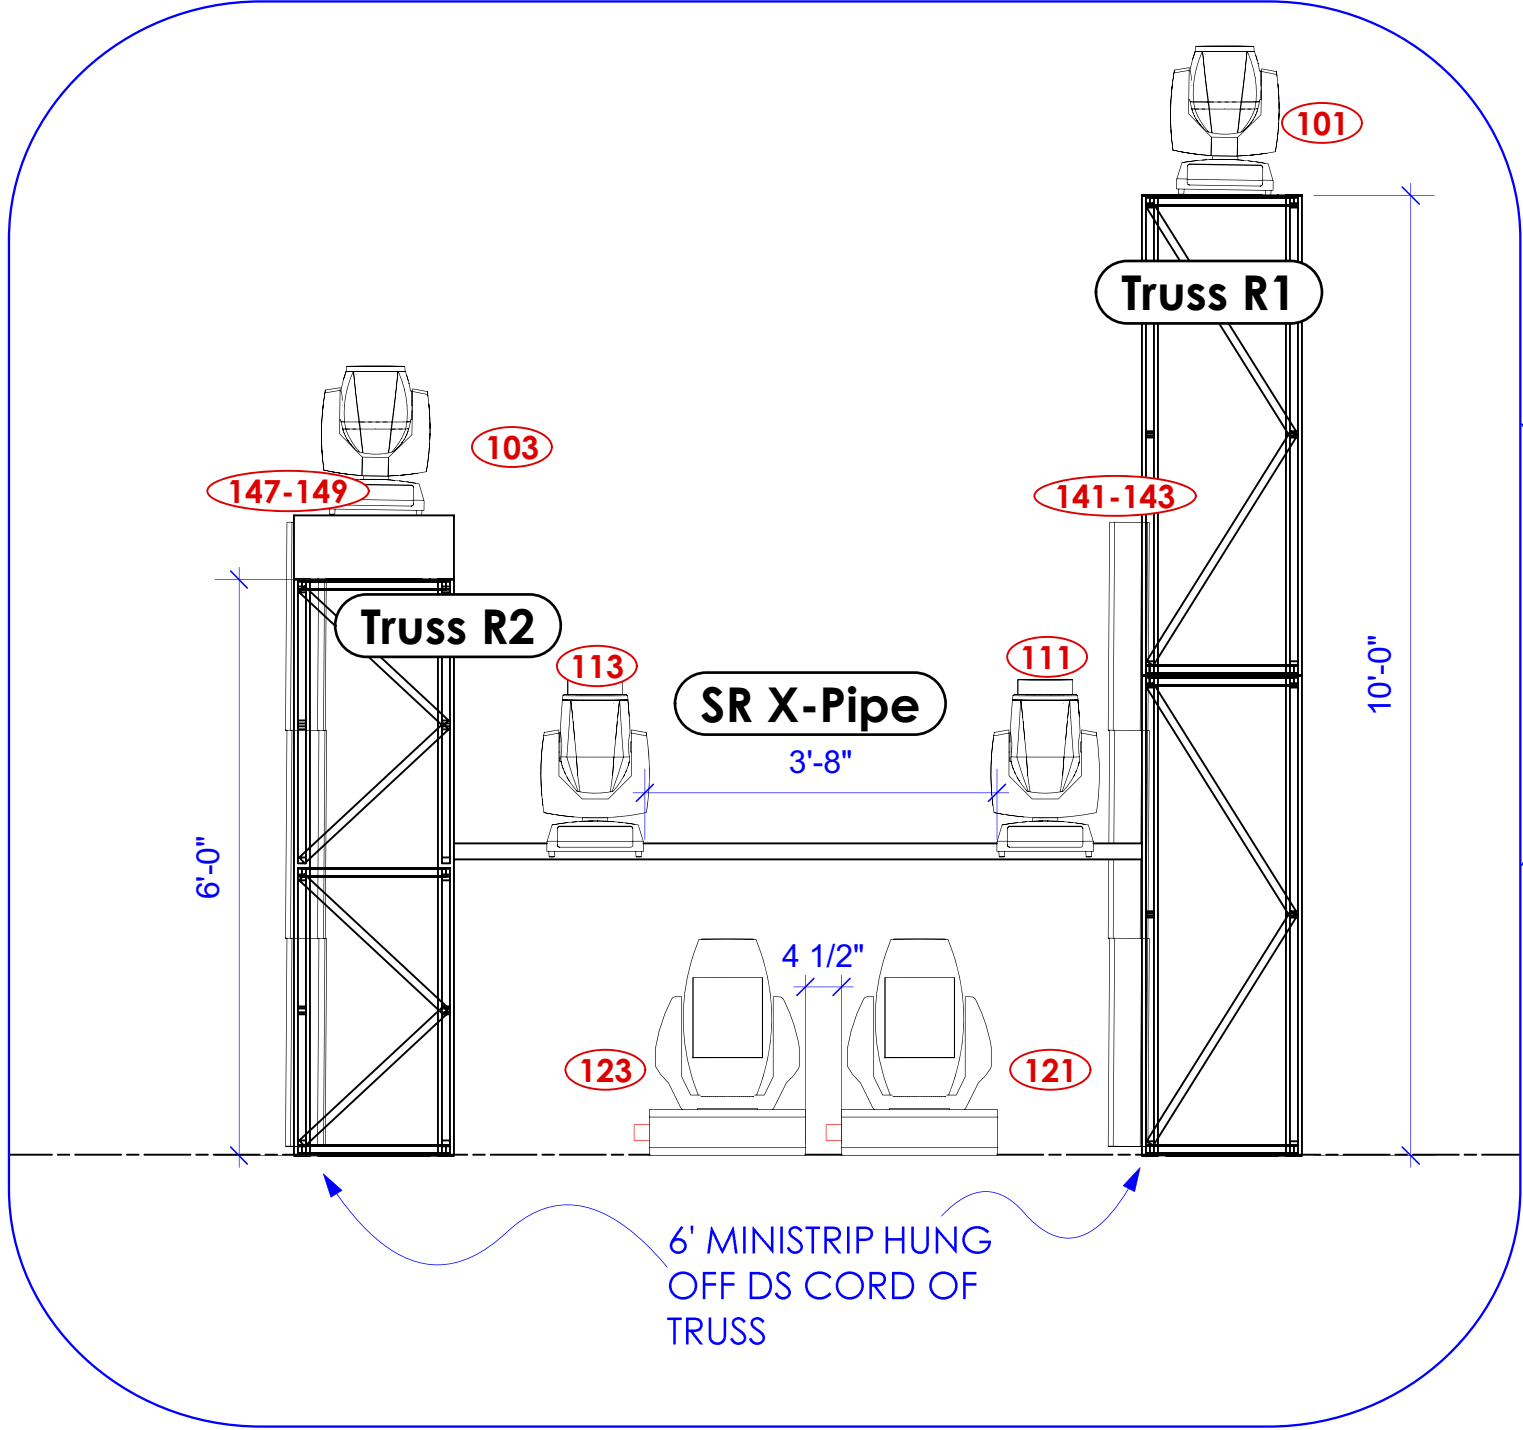


PLAN VIEW

SCALE: 1/4" = 1'0"

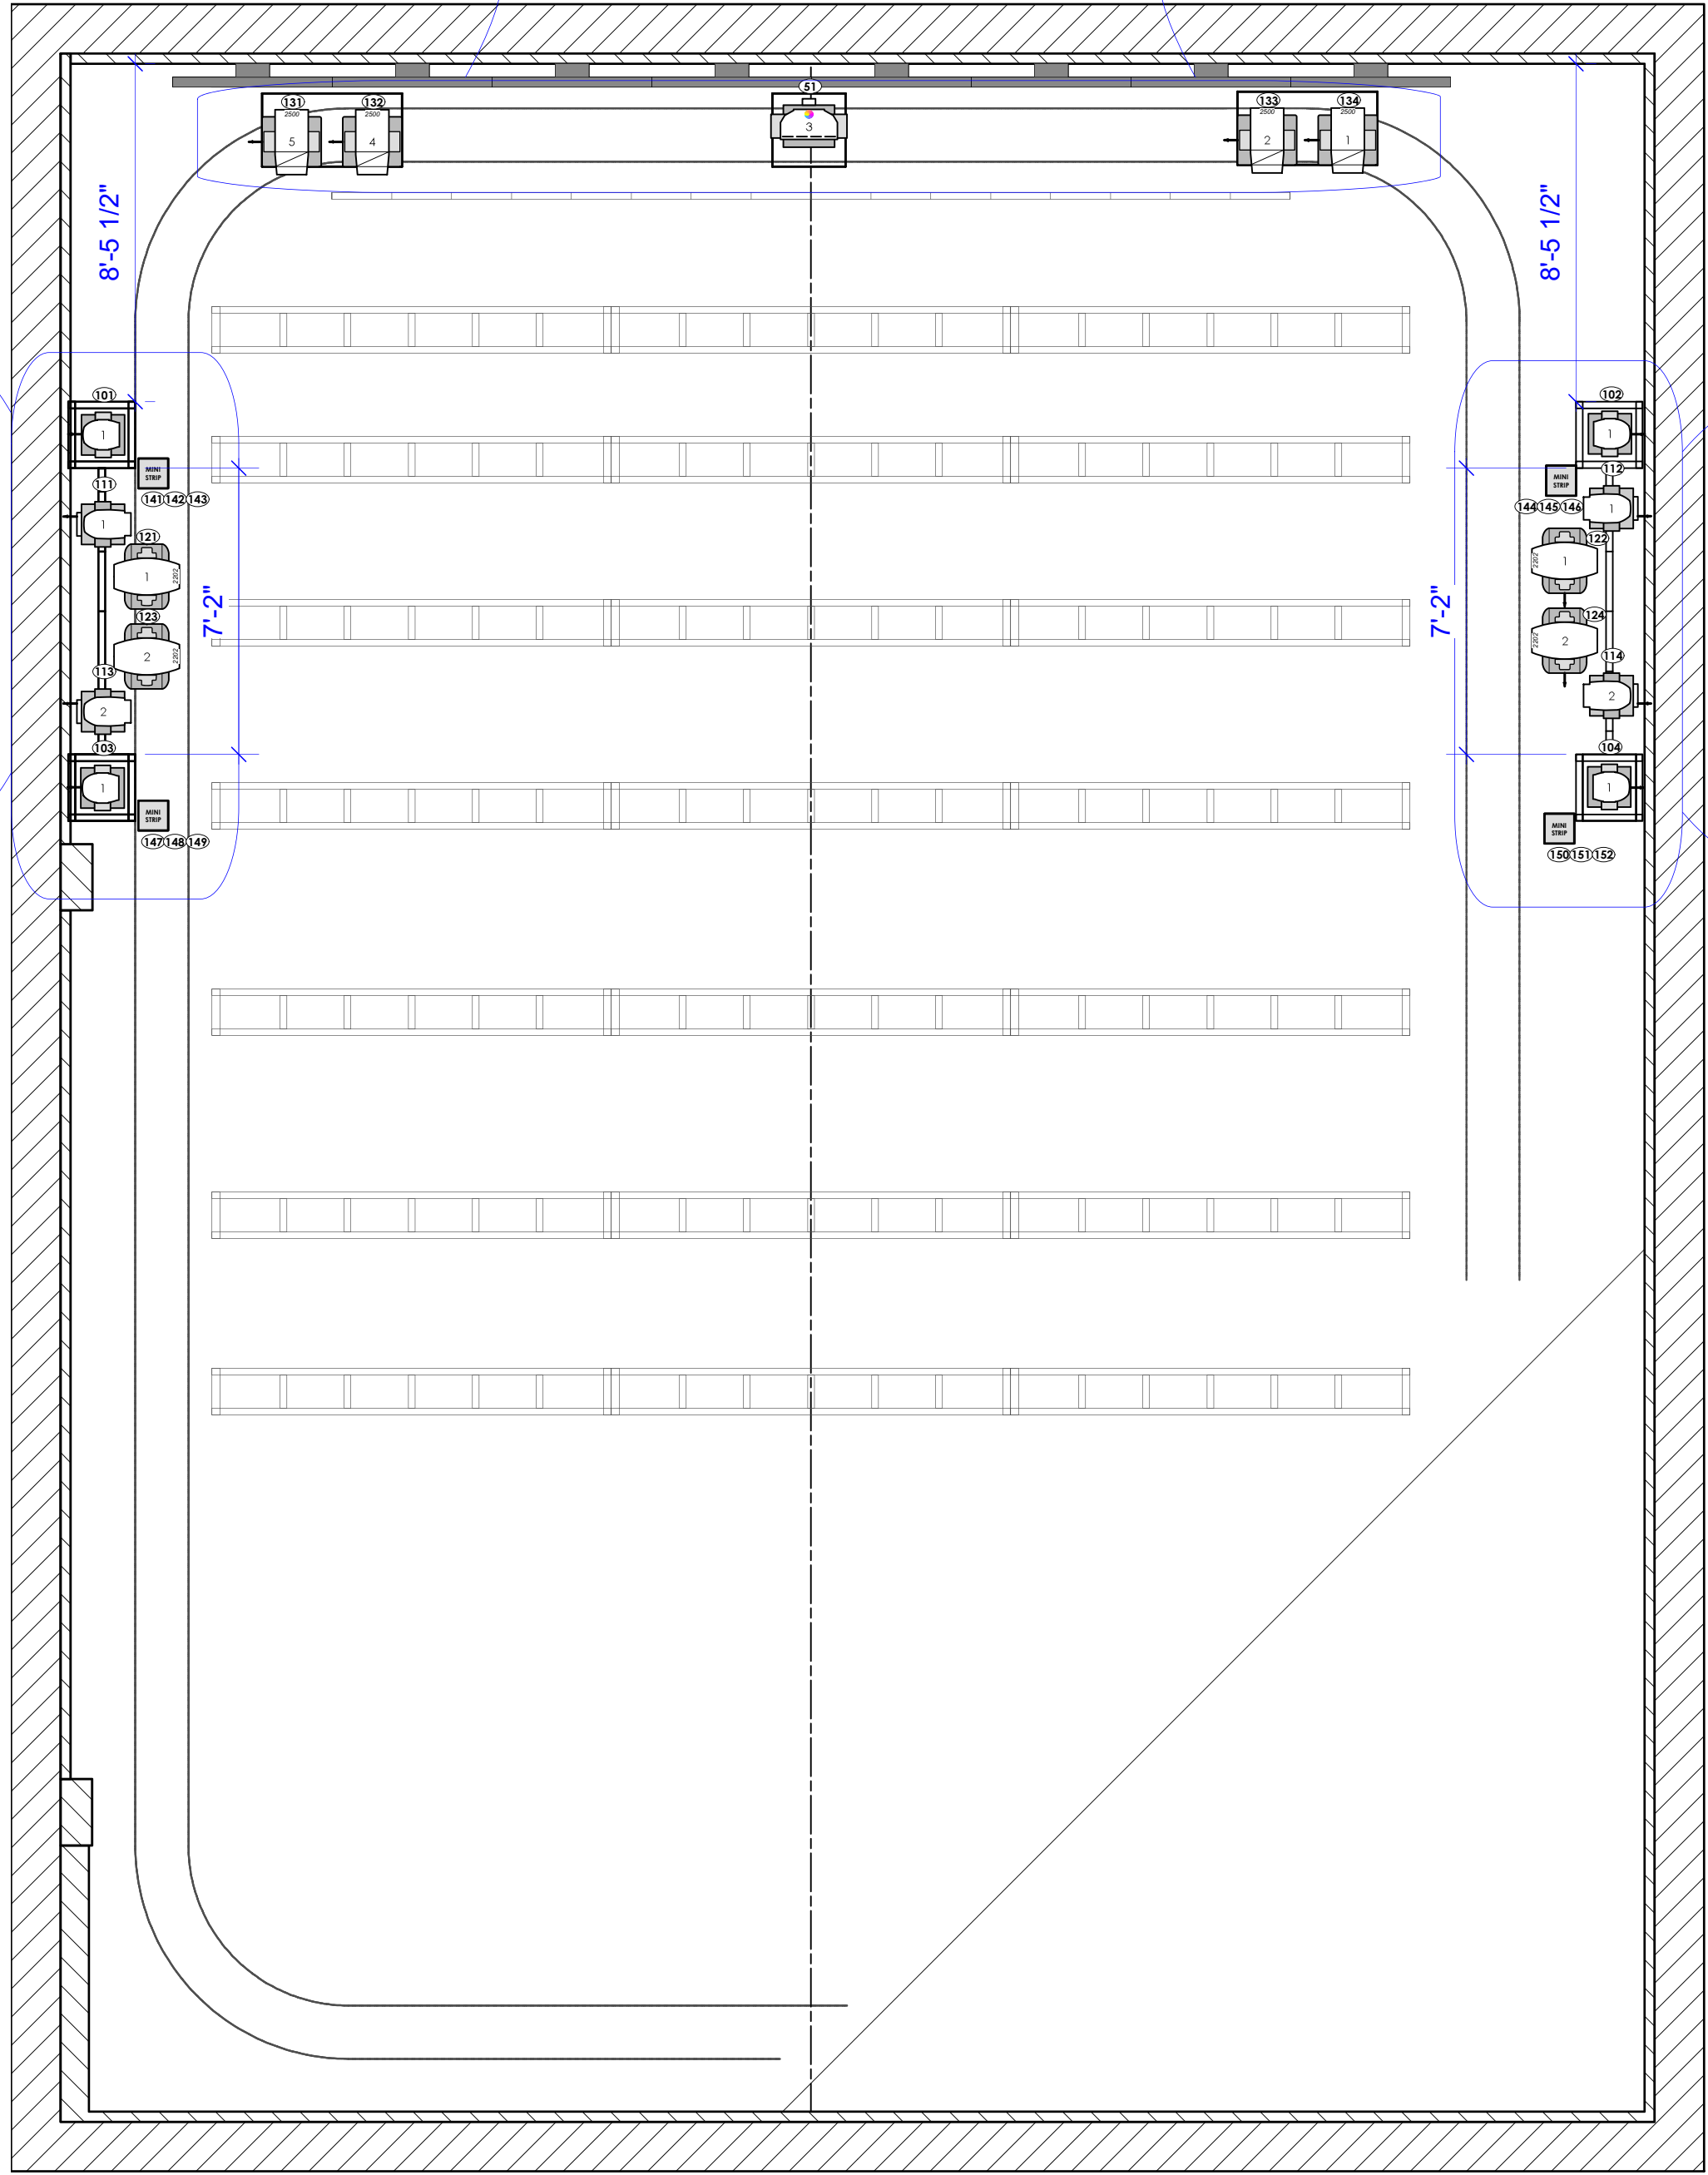


SL DECK ELEVATION

SCALE: 1/2" = 1'0"

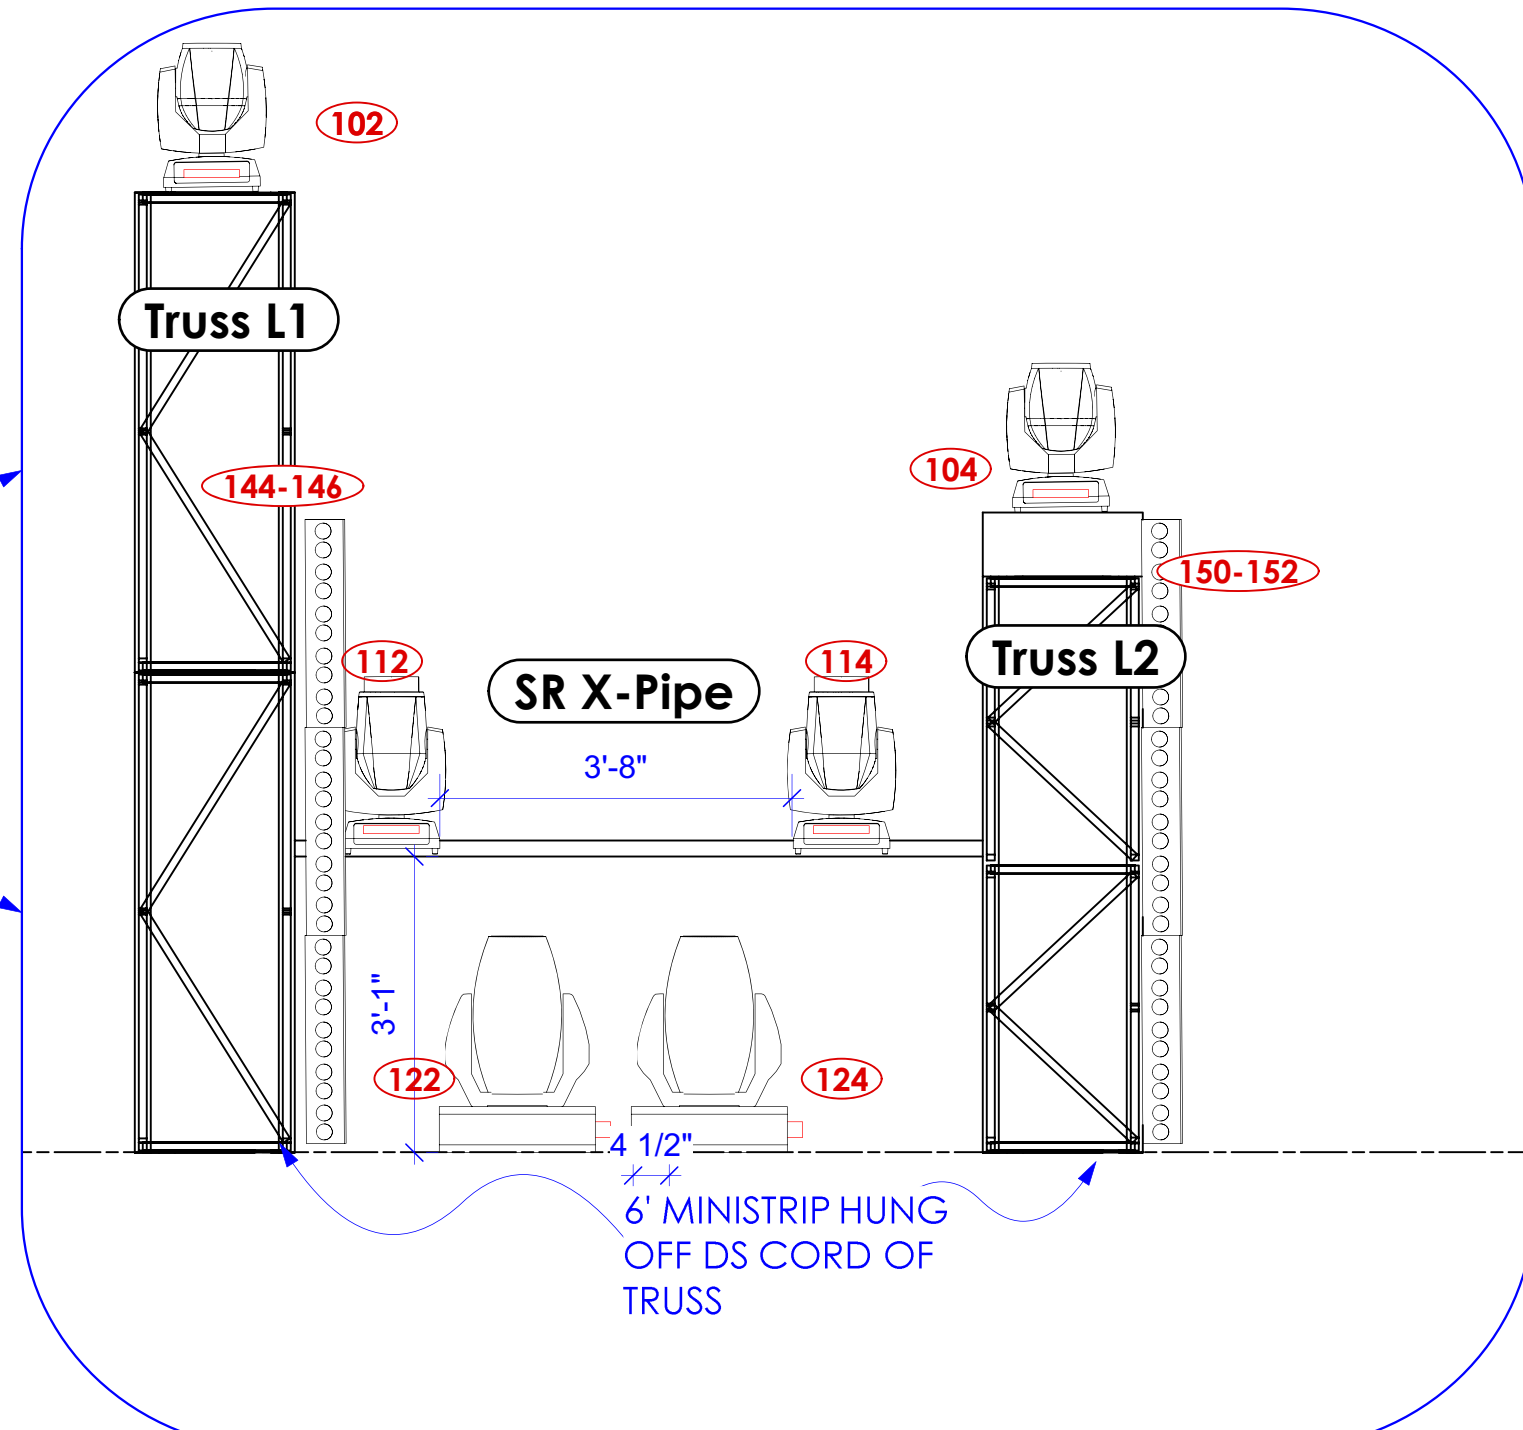

SLED DETAIL


Scale: 1" = 1'0"

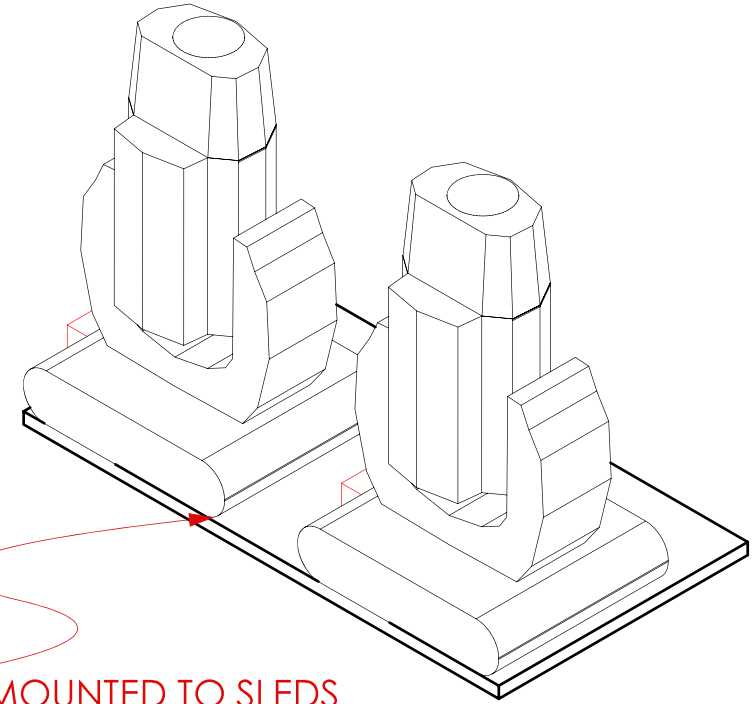


FIXTURES MOUNTED TO SLEDS
FOR EASY TRANSPORT ON/OFF
STAGE

Symbol Key


Moving Light

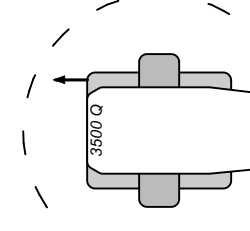


Varilite VL 3500 Q
Spot

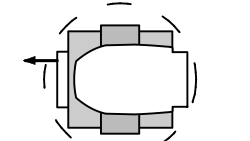


Clay Paky Sharpy
Wash 330

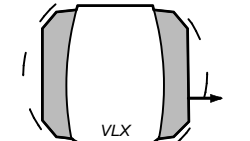


Varilite VLX Wash

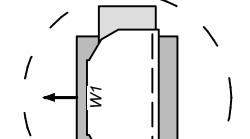


High End
ShapeShifter
White

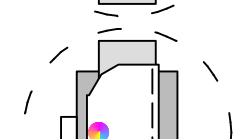


High End
ShapeShifter
Color

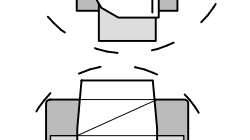

Varilite VL 2500
Spot

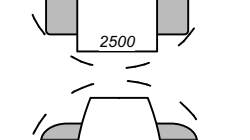


Varilite VL 2202

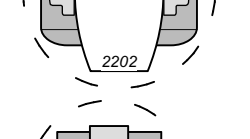

Clay Paky Sharpy


Conventional

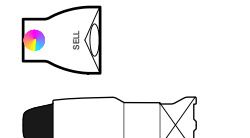


ETC D40 Lustr
SELL40




ETC Source4
19deg 750W

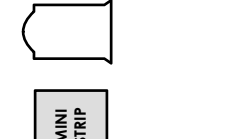

Martin Atomic
3000 DMX

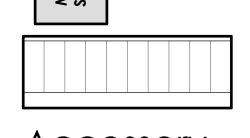

Selecon Acclaim
Fresnel

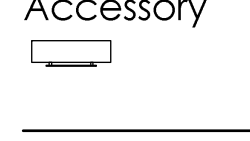

Altman Zip Strip




Altman Zip Strip



Wybron
Forerunner 4"

Accessory

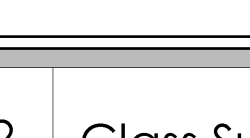


Wybron
Forerunner 4"

Typical



 Wybron
Forerunner 4"




Wybron
Forerunner 4"



Wybron
Forerunner 4"




Wybron
Forerunner 4"

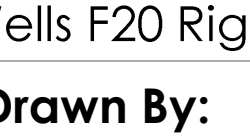

Wybron
Forerunner 4"




Wybron
Forerunner 4"

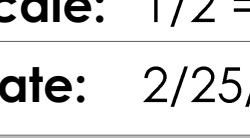

Wybron
Forerunner 4"



 Wybron
Forerunner 4"



Wybron
Forerunner 4"



Wybron
Forerunner 4"

2 Class Submission 10/14/2019
1 Prelim 10/8/2019

WELLS CONCERT RIG
FALL 2020

Filename:
Wells F20 Rig Feb20 Update.vwx

Drawn By:
A. TALBOT


Scale: 1/2"=1'0"
Date: 2/25/20

Deck Plot

Page #
3
Of: 6


LED WALL PLAN VIEW

SCALE: 1/2" = 1'0"
NORTH

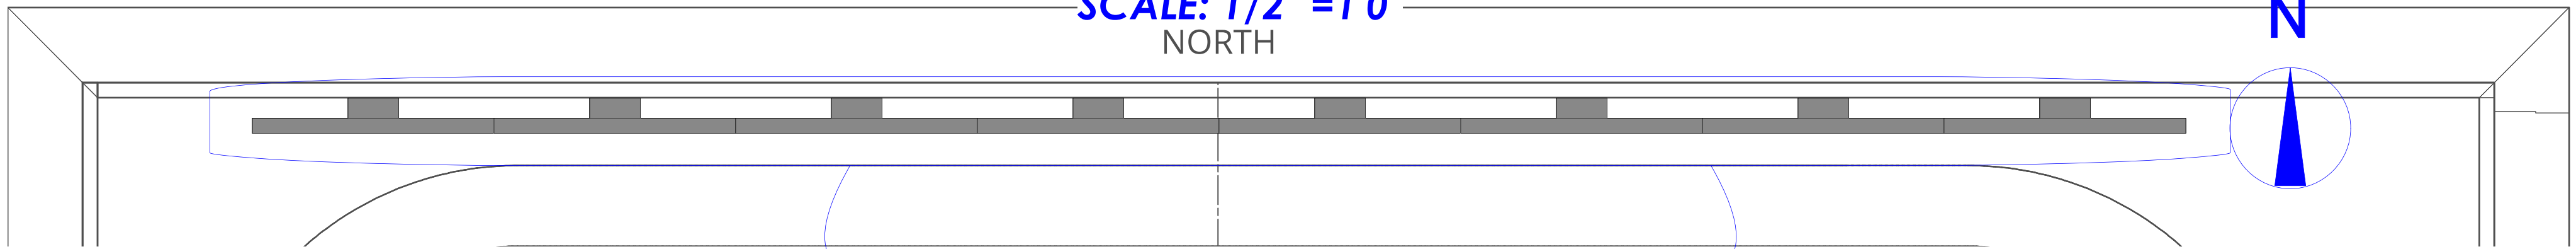


LED WALL ELEVATION

SCALE: 1/2" = 1'0"

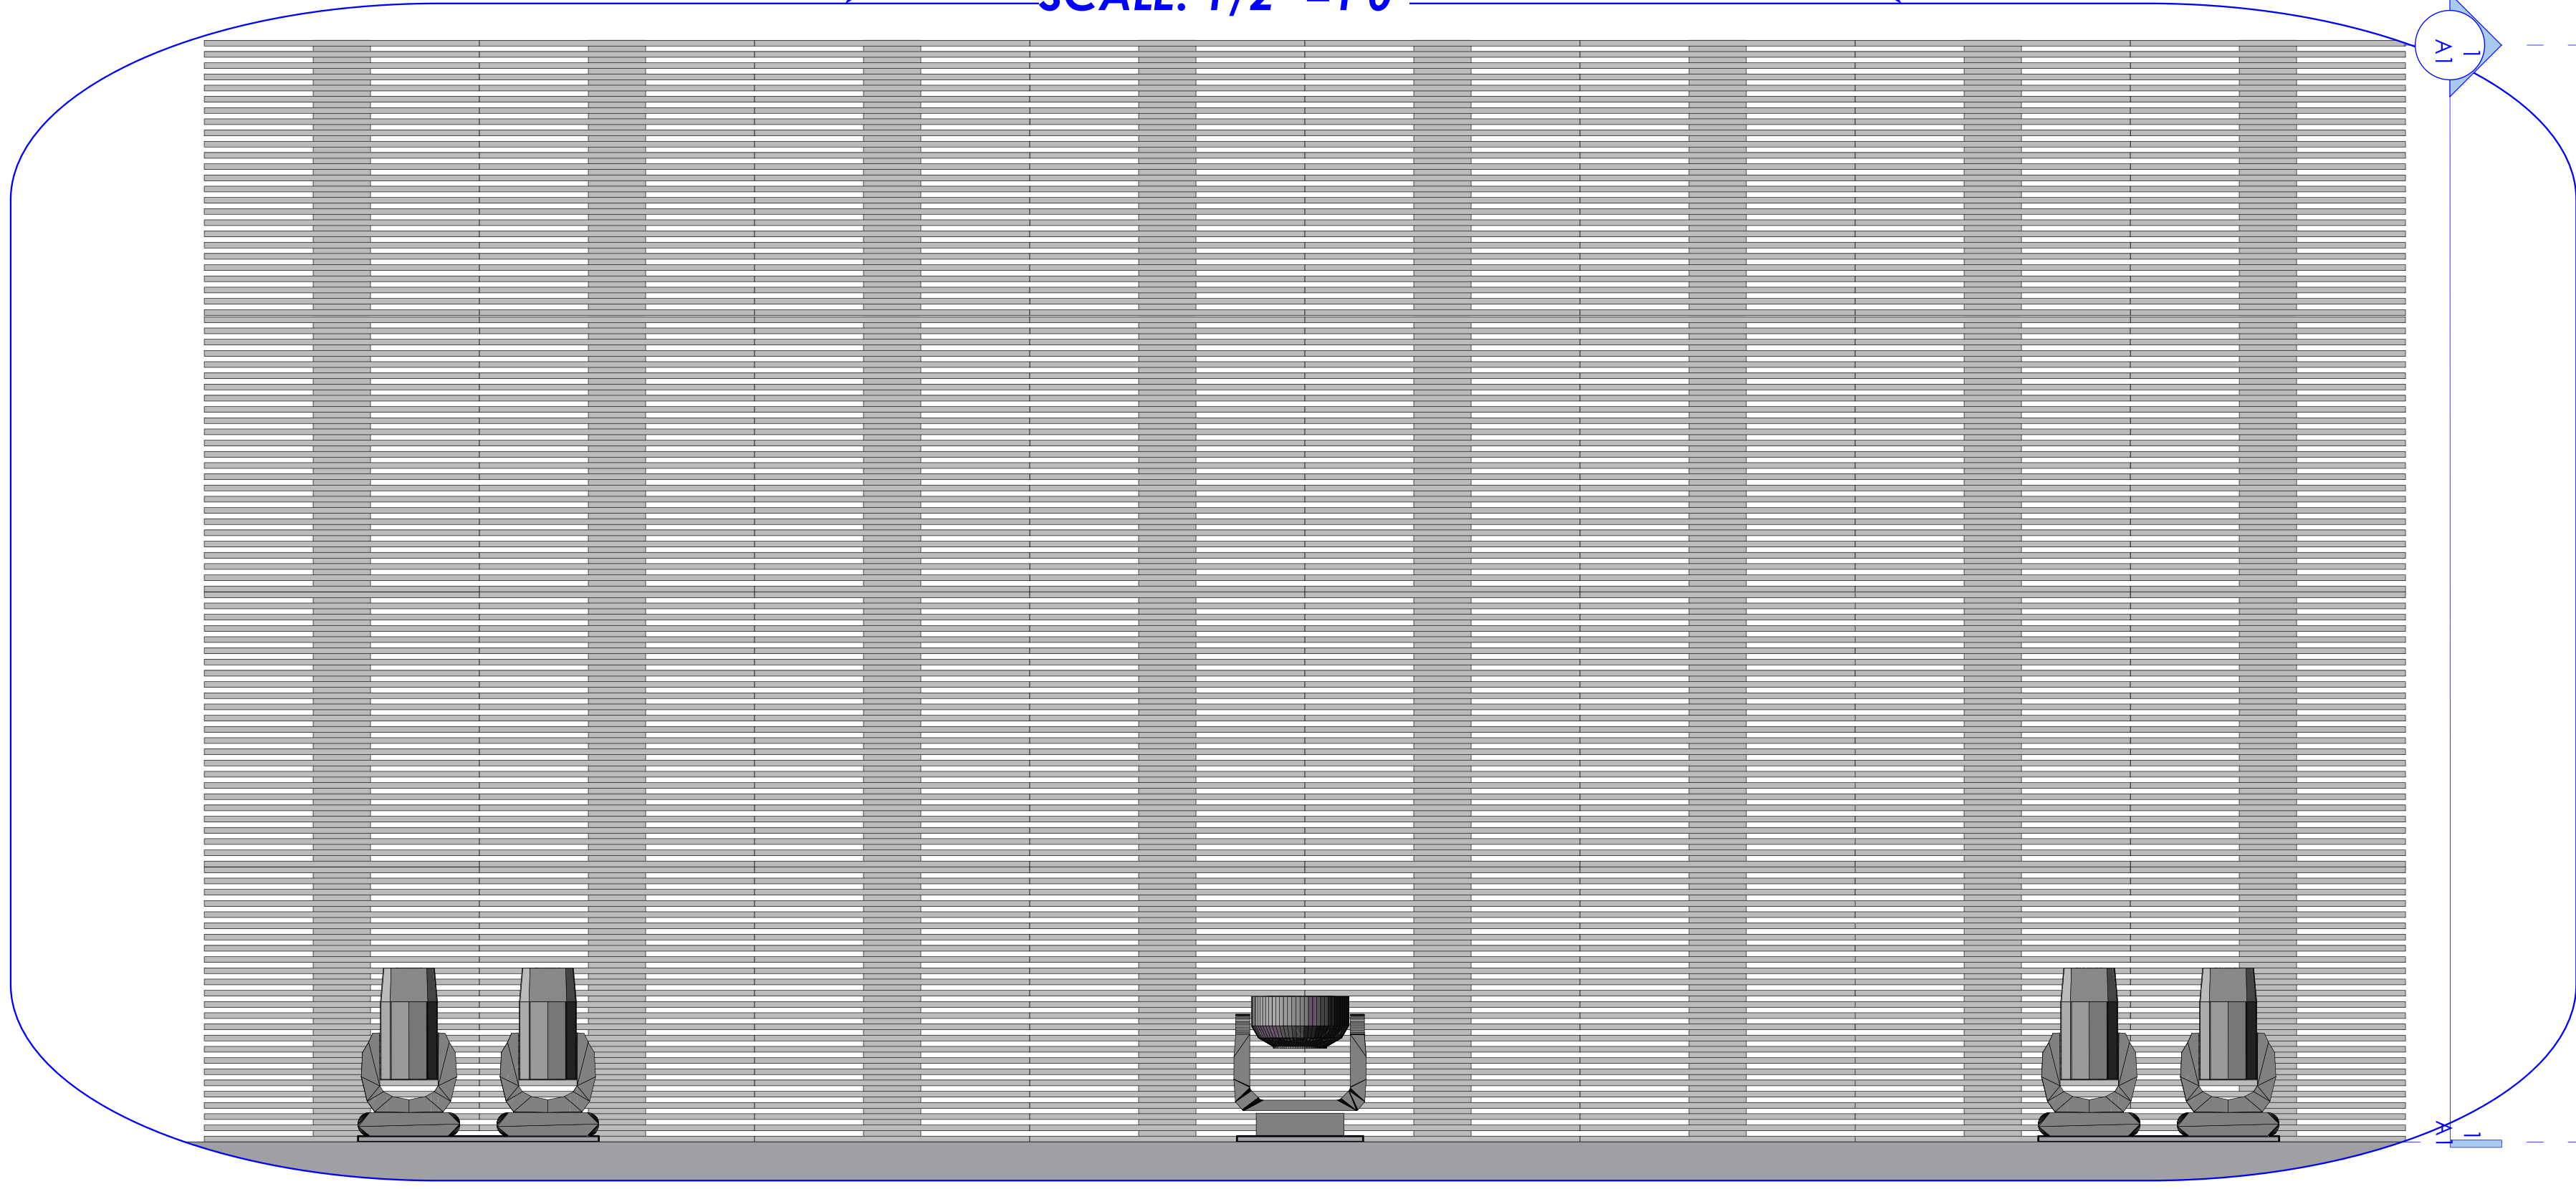

LED WALL PANEL LAYOUT

Scale: 1/2" = 1'0"

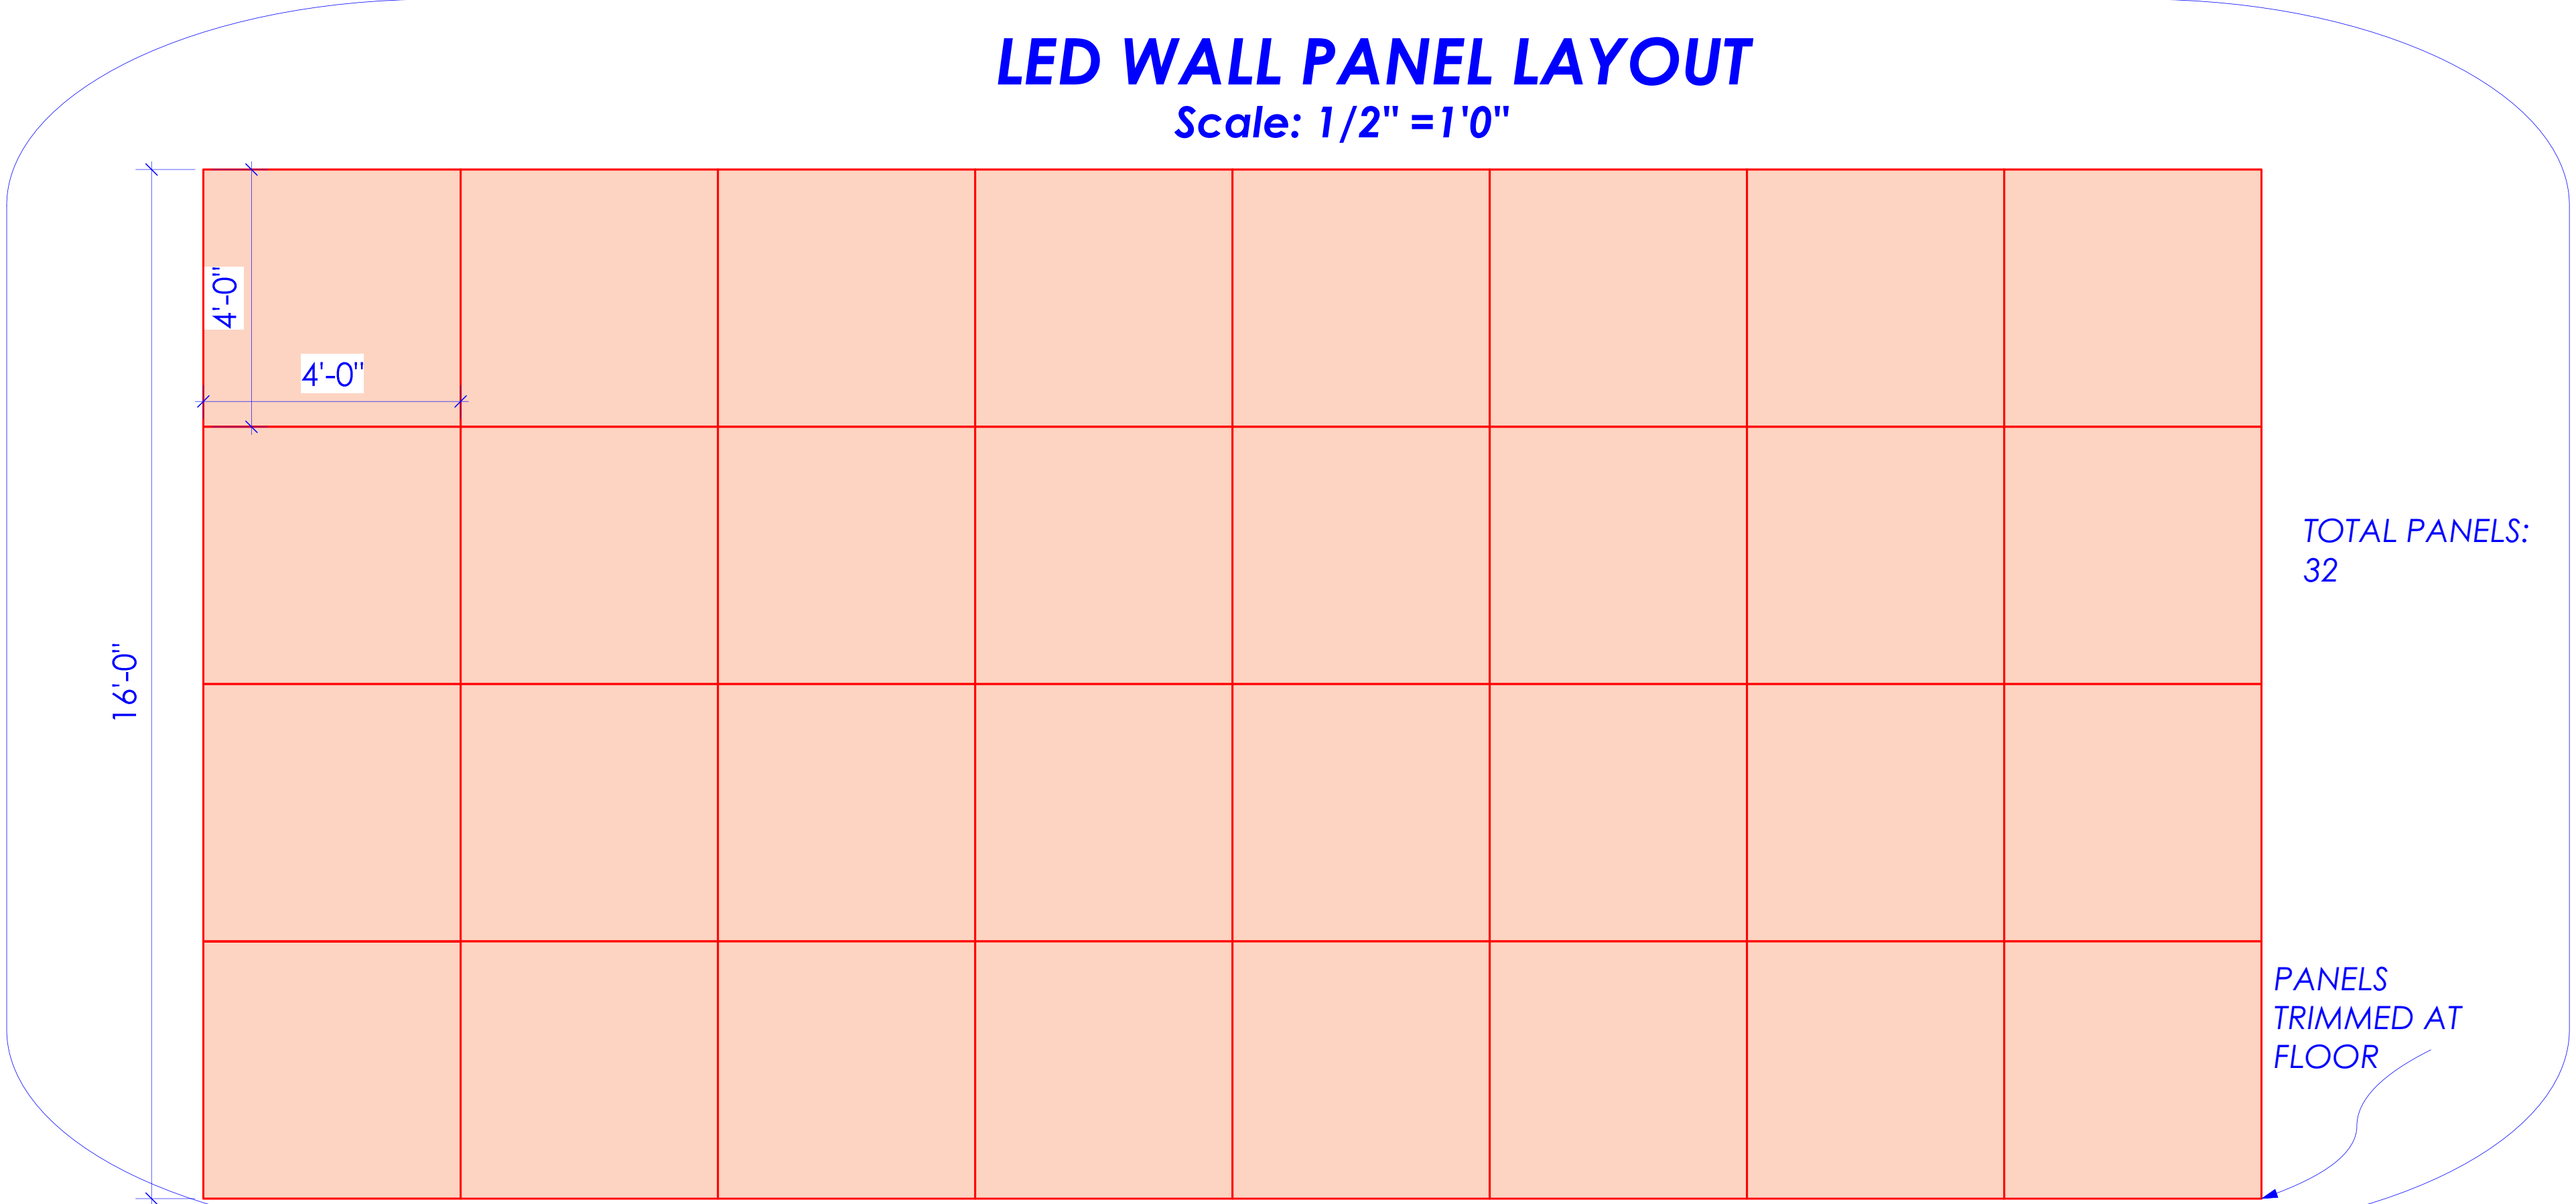

TOTAL PANELS:
32


PANELS
TRIMMED AT
FLOOR

NOTES:

ALL PANELS TO BE CONTROLLED BY MBOX
IN DESIGNER MODE
MBOX TO BE PATCHED INTO CH. 301 FOR
MASTER, 311-322 FOR LAYER

LED WALL SECTION


SCALE: 1/2" = 1'0"

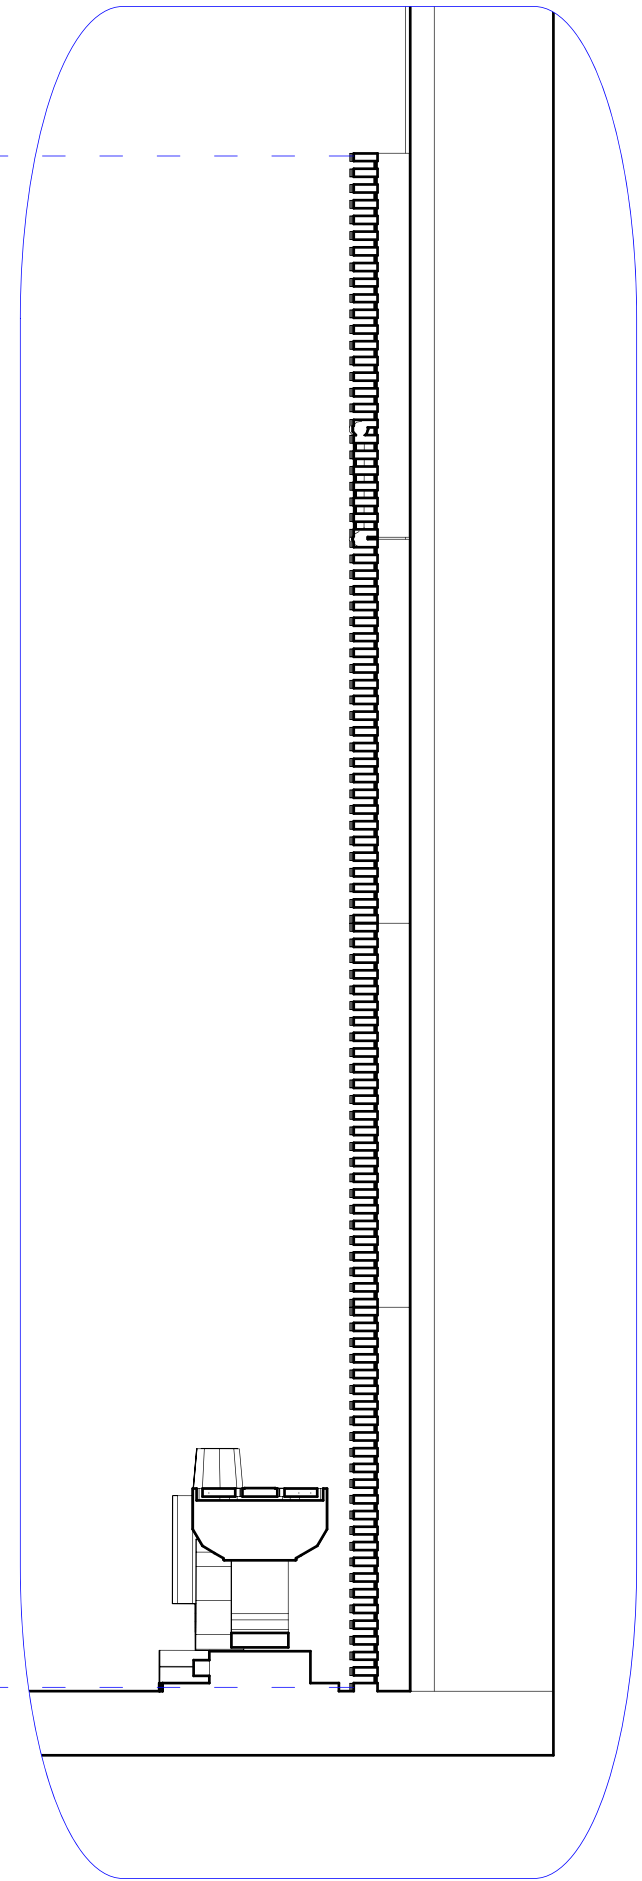

PANEL EXAMPLE ISO


Type: ELATION EPV375 HO

SCALE: 1" = 1'0"

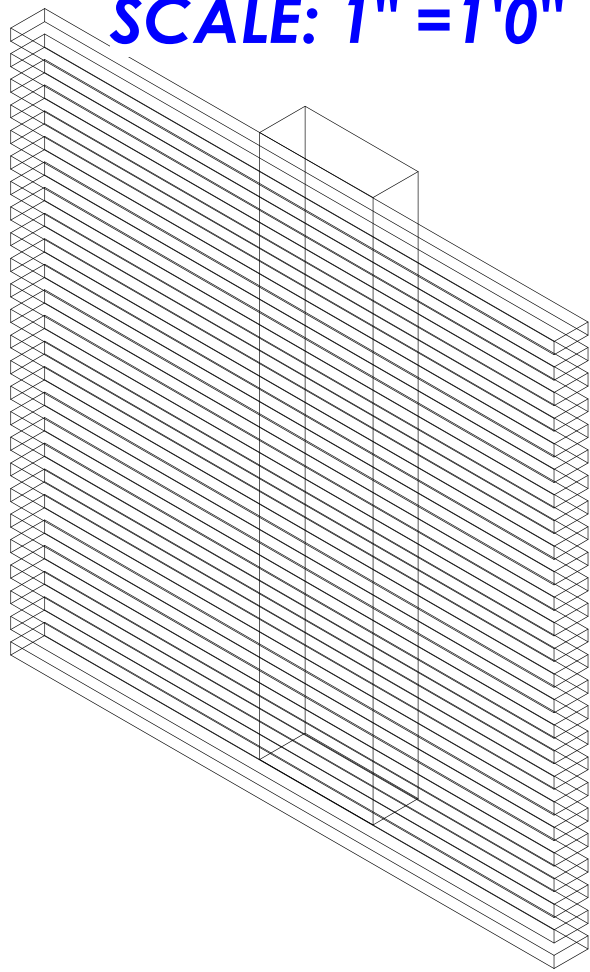


Symbol Key


Moving Light

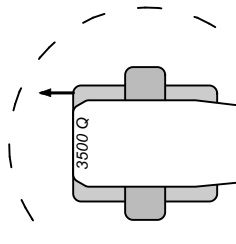


Varilite VL 3500 Q
Spot

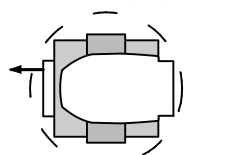


Clay Paky Sharpy
Wash 330

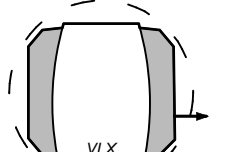


Varilite VLX Wash

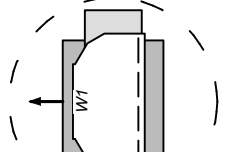


High End
ShapeShifter
White

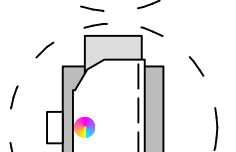


High End
ShapeShifter
Color

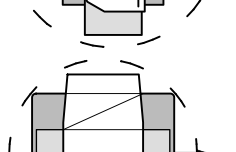

Varilite VL 2500
Spot

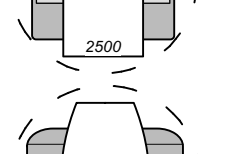


Varilite VL 2202

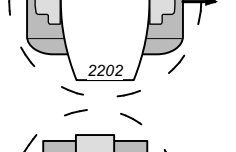


Clay Paky Sharpy


Conventional

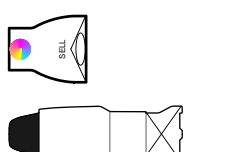


ETC D40 Lustr
SELL40

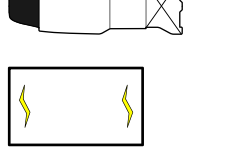

ETC Source4
19deg 750W

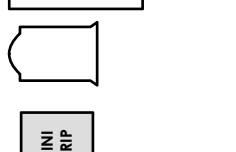

Martin Atomic
3000 DMX

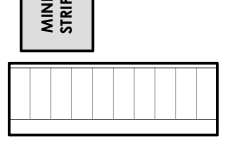

Selecon Acclaim
Fresnel



Altman Zip Strip




Altman Zip Strip

Accessory



Wybron
Forerunner 4"

Typical

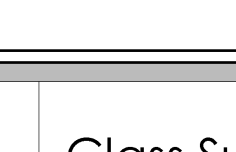

Channel

2	Class Submission	10/14/2019
1	Prelim	10/8/2019

WELLS CONCERT RIG
FALL 2020

Filename:
Wells F20 Rig Feb20 Update.vwx

Drawn By:
A. TALBOT


Scale: 1/2"=1'0"
Date: 2/25/20

Page #

4


Of: 6

LED Wall Detail

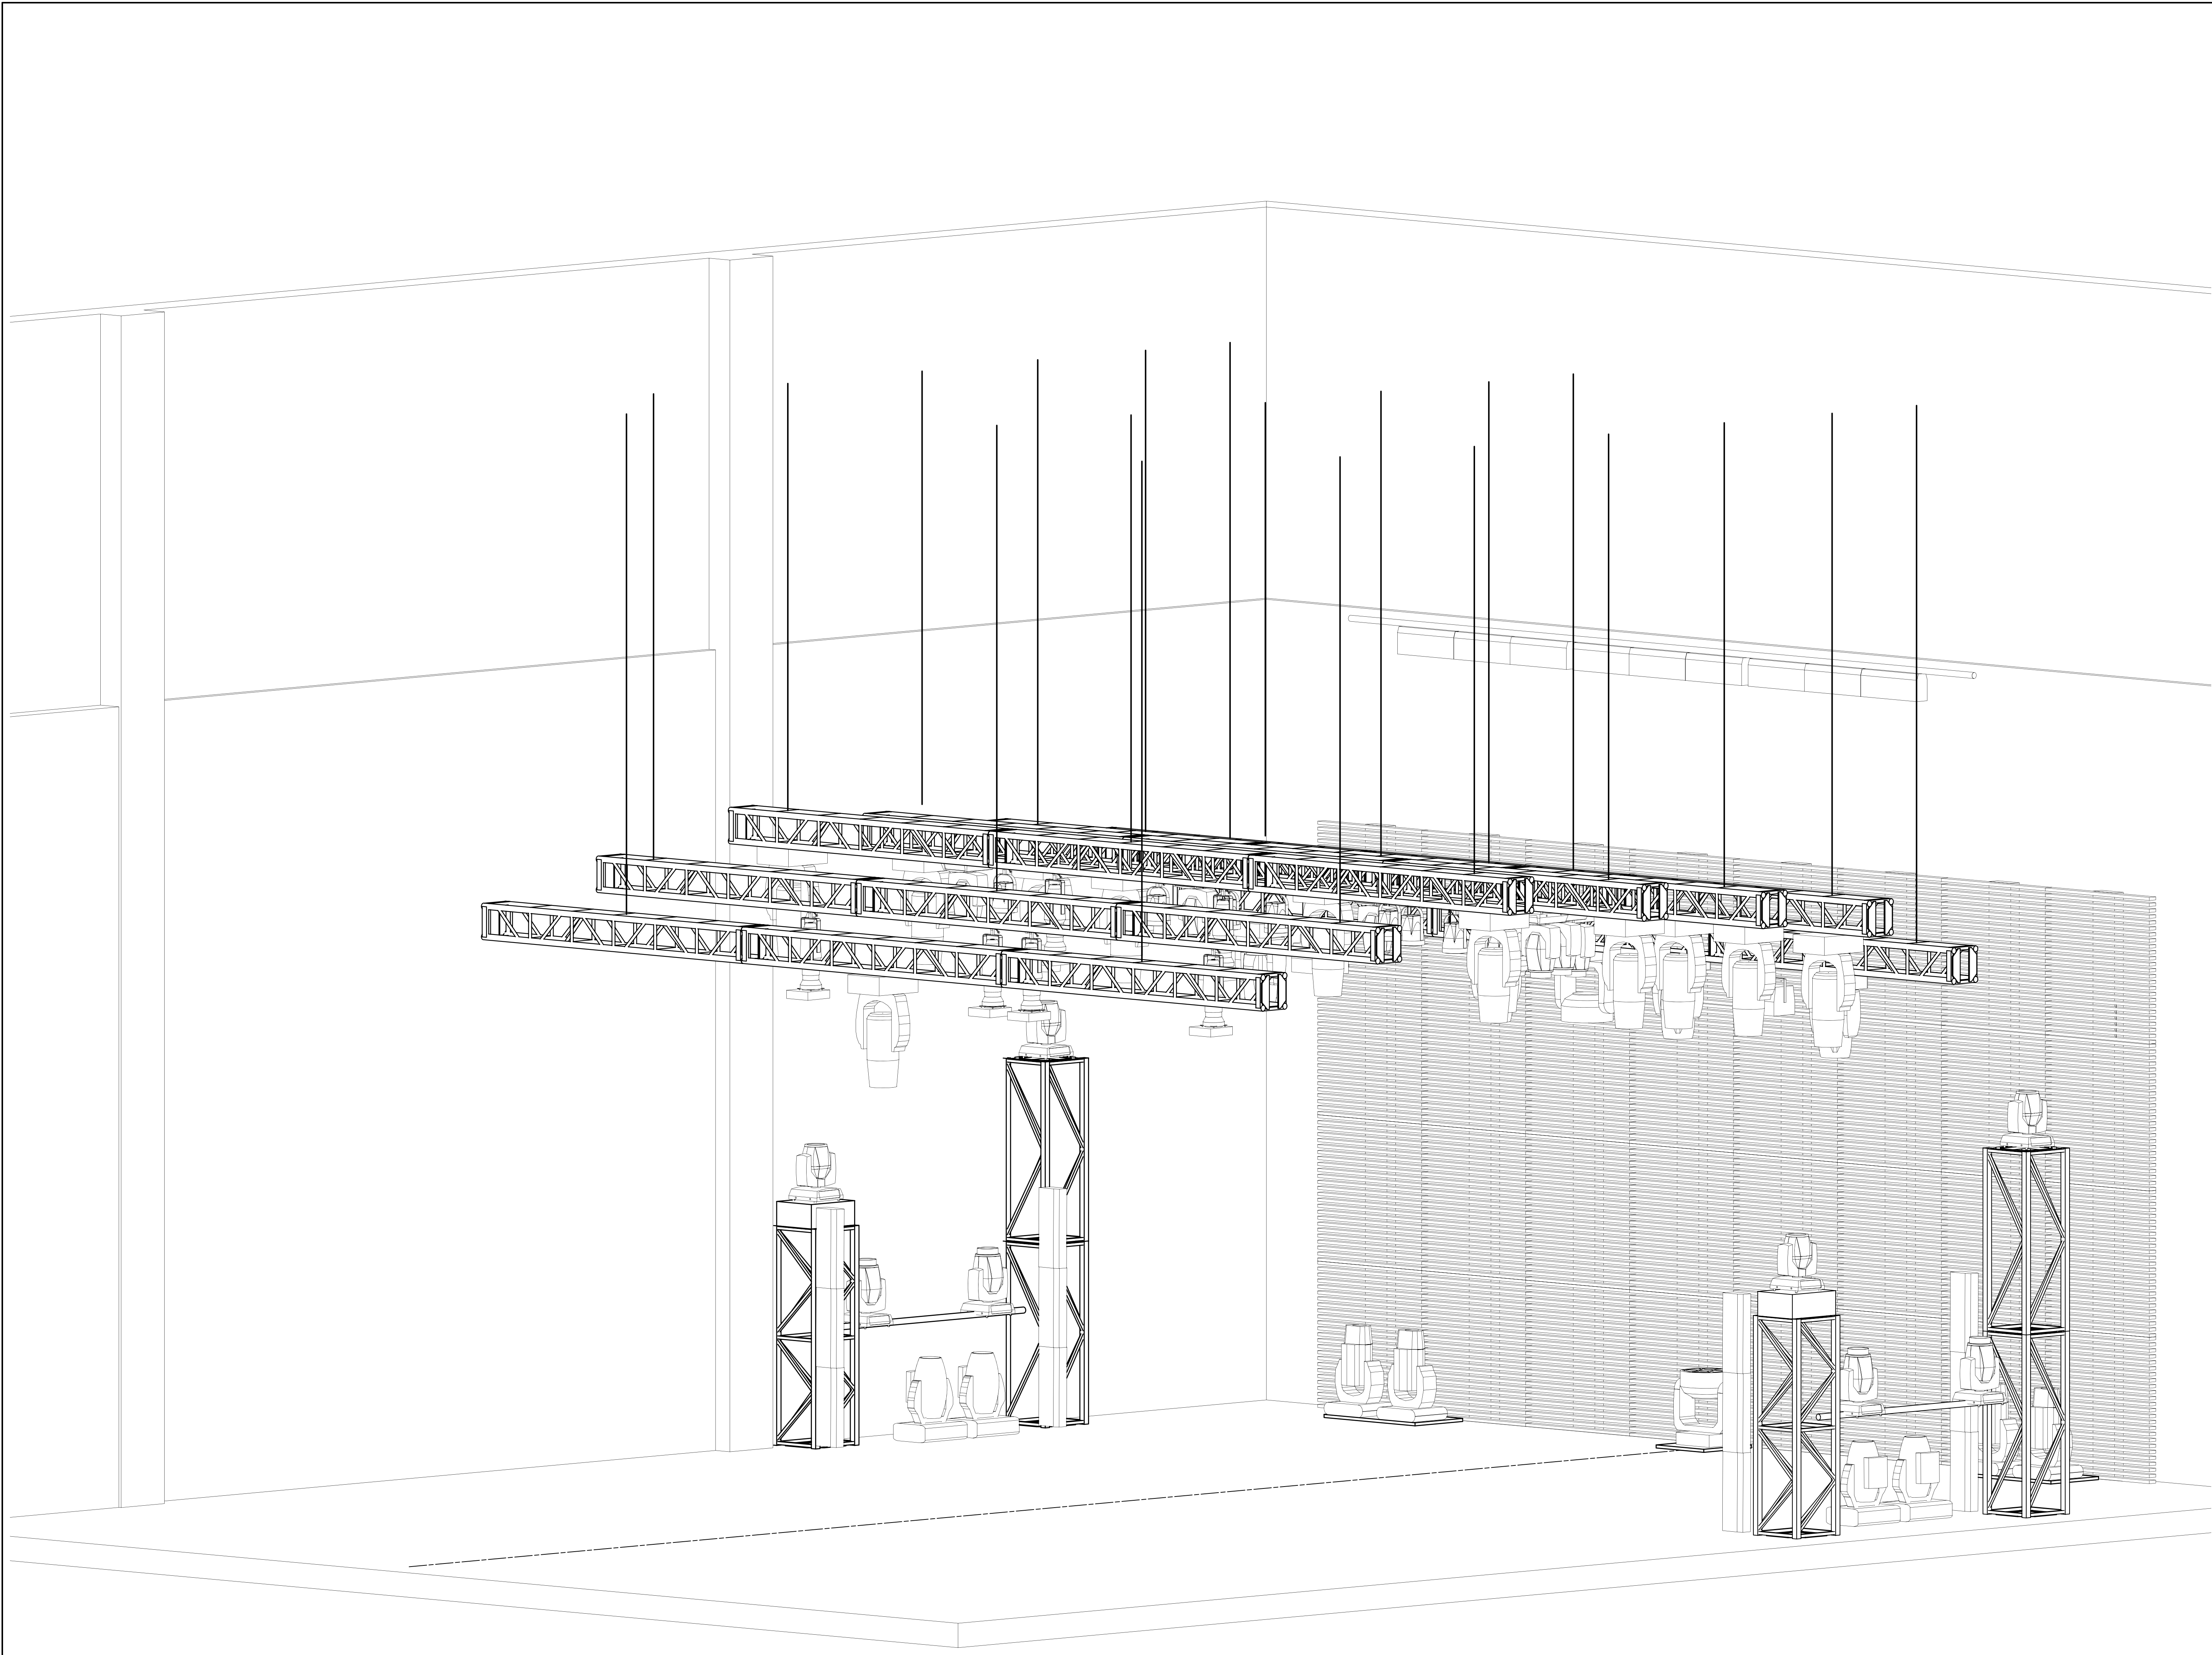


Symbol Key


Moving Light

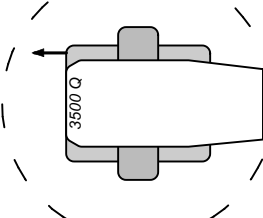


Varilite VL 3500 Q Spot

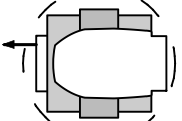


Clay Paky Sharpy Wash 330

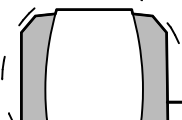


Varilite VLX Wash

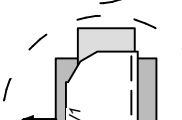


High End ShapeShifter White

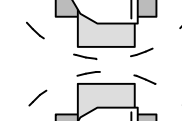


High End ShapeShifter Color

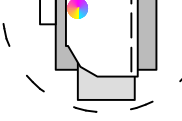

Varilite VL 2500 Spot

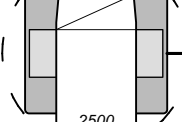

Varilite VL 2202

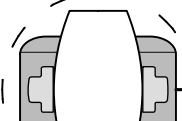

Clay Paky Sharpy

Conventional



ETC D40 Lustr SELL40



ETC Source4 19deg 750W



 
Martin Atomic 3000 DMX



Selecon Acclaim Fresnel



Altman Zip Strip




Altman Zip Strip

Accessory



Wybron Forerunner 4"

Typical

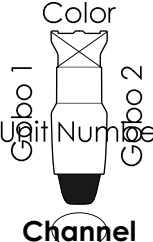

Color
Light Number
Channel

2	Class Submission	10/14/2019
1	Prelim	10/8/2019

WELLS CONCERT RIG
FALL 2020

Filename:
Wells F20 Rig Feb20 Update.vwx

Drawn By:
A. TALBOT


Scale: 1/2"=1'0"

Date: 2/25/20

Page #
5


Of: 6

Isometric

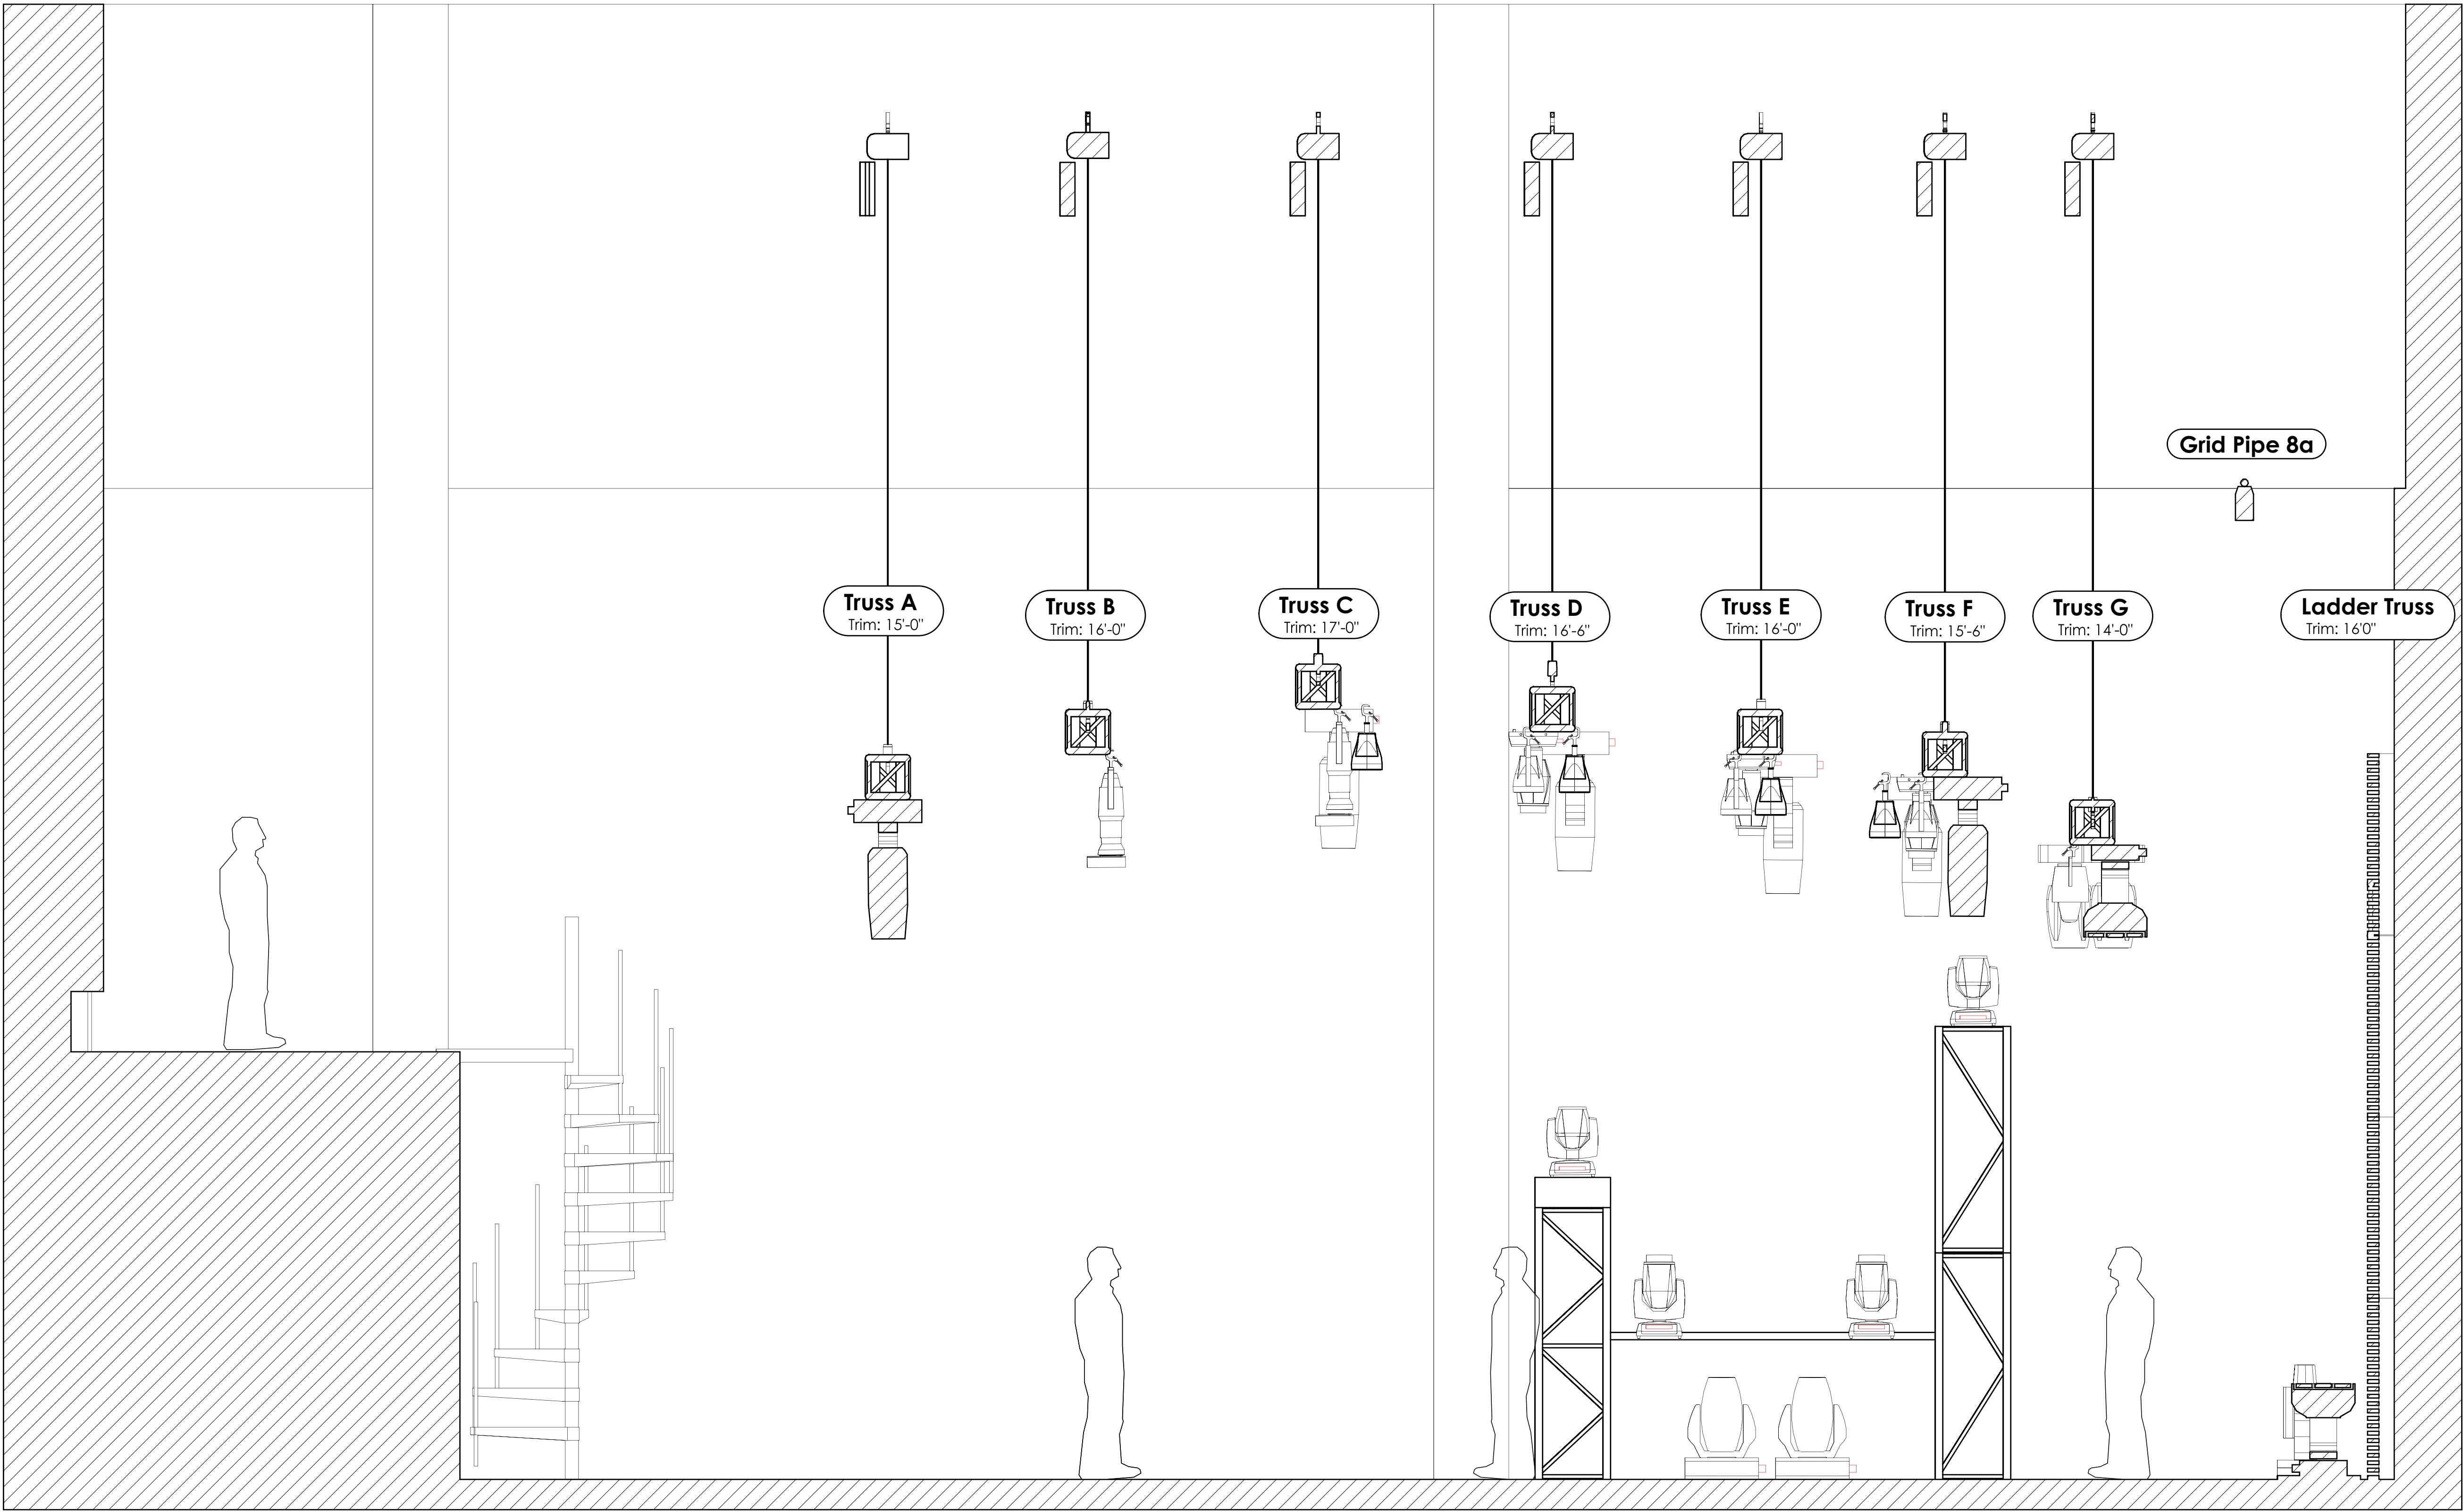


Symbol Key


Moving Light

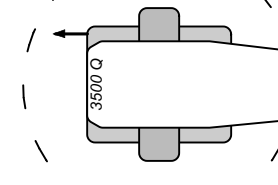


Varilite VL 3500 Q Spot

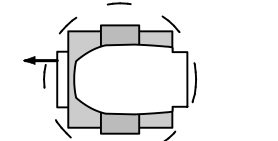


Clay Paky Sharpy Wash 330

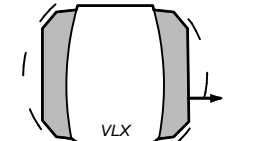


Varilite VLX Wash

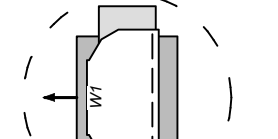


High End ShapeShifter White

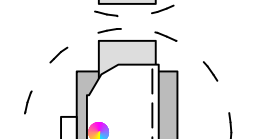


High End ShapeShifter Color

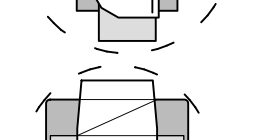

Varilite VL 2500 Spot

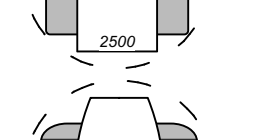

Varilite VL 2202

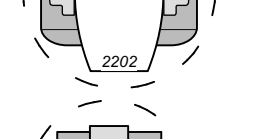


Clay Paky Sharpy


Conventional




ETC D40 Lustr SELL40

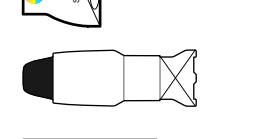

ETC Source4 19deg 750W

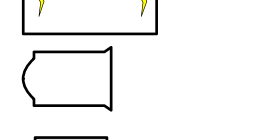

Martin Atomic 3000 DMX

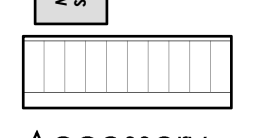

Selecon Acclaim Fresnel



Altman Zip Strip



Altman Zip Strip

Accessory



Wybron Forerunner 4"

Typical



Color
Light Number
Channel

2	Class Submission	10/14/2019
1	Prelim	10/8/2019

WELLS CONCERT RIG
FALL 2020

Filename:
Wells F20 Rig Feb20 Update.vwx

Drawn By:
A. TALBOT

Scale: 1/2"=1'0"

Date: 2/25/20

Page #
6
Of: 6

Section